
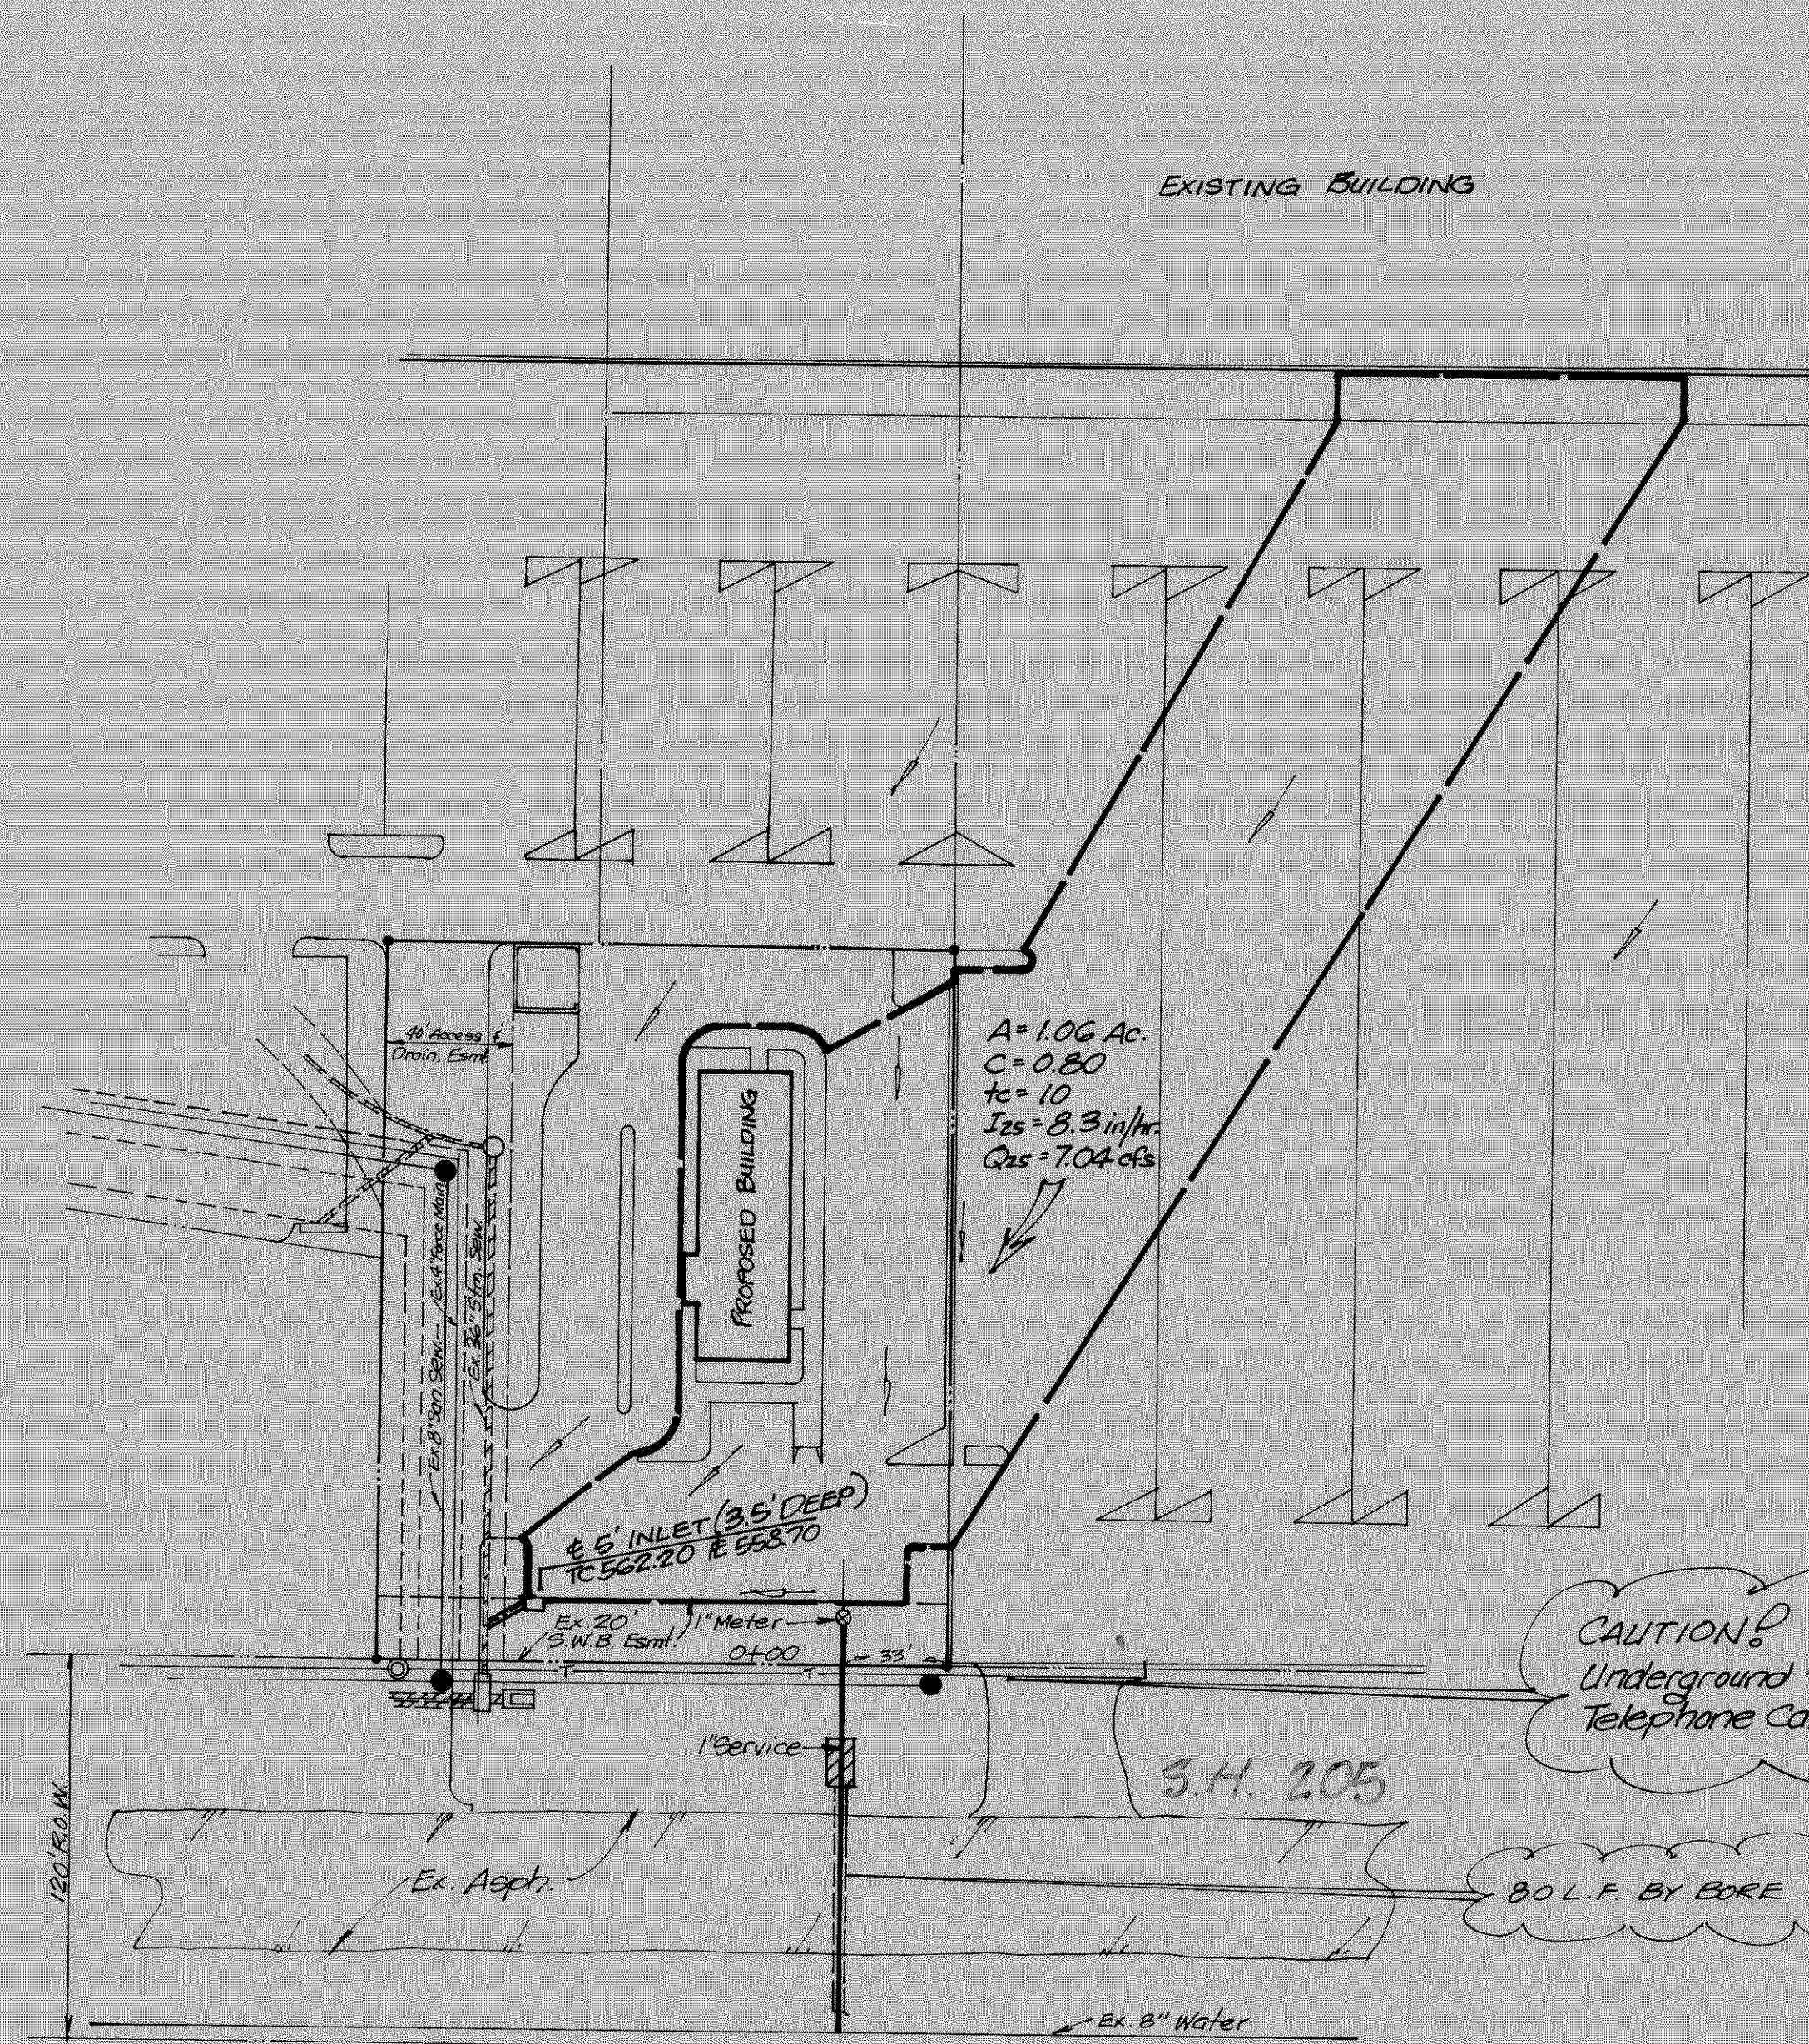


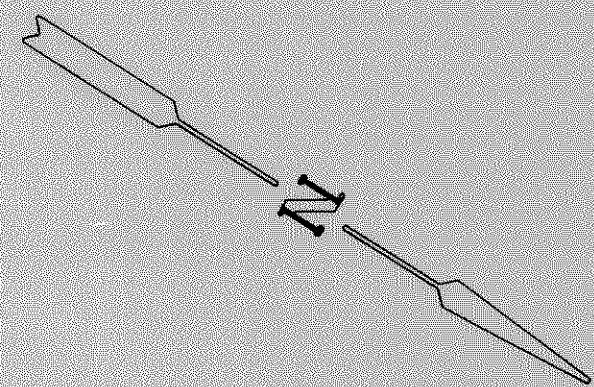


NOTE: Verify Location of Existing Utilities Prior to Construction.

CAUTION! Underground Southwestern Bell Telephone Cable In This Area.

80 L.F. BY BORE

PLAN SCALE: 1"=50'

PROFILE SCALE: 1"=4' Hgt. 1"=6' Vert.

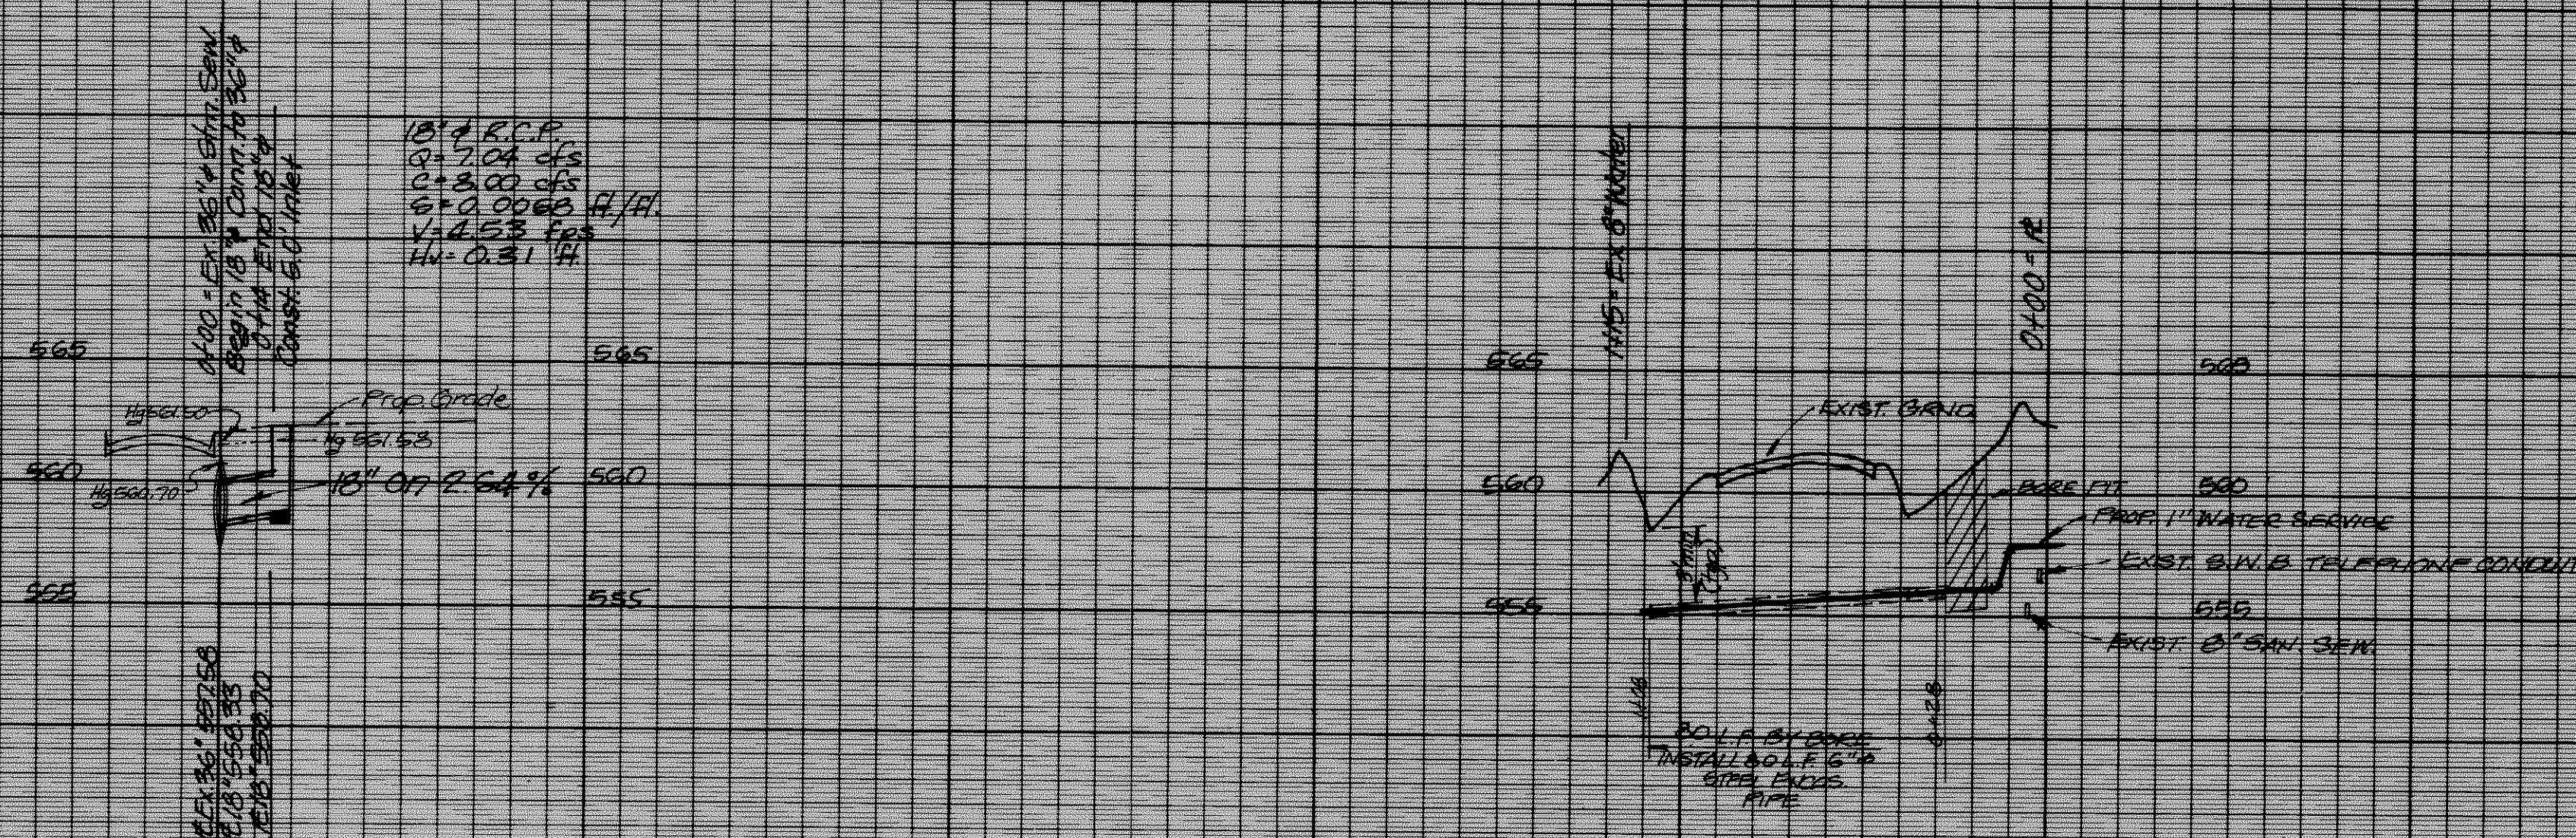

AS BUILT

HAROLD L. EVANS
CONSULTING ENGINEER
2331 GUS THOMASSON RD. SUITE 102
DALLAS, TEXAS 75228
PHONE (214) 328-8133
SCALE DATE JOB NO.
NOTED 2-2-87 8713
REVISED 3-2-87

UTILITY PLAN
KENTUCKY FRIED CHICKEN
ROCKWALL CENTRAL SHOPPING CENTER
ROCKWALL, ROCKWALL COUNTY, TEXAS