

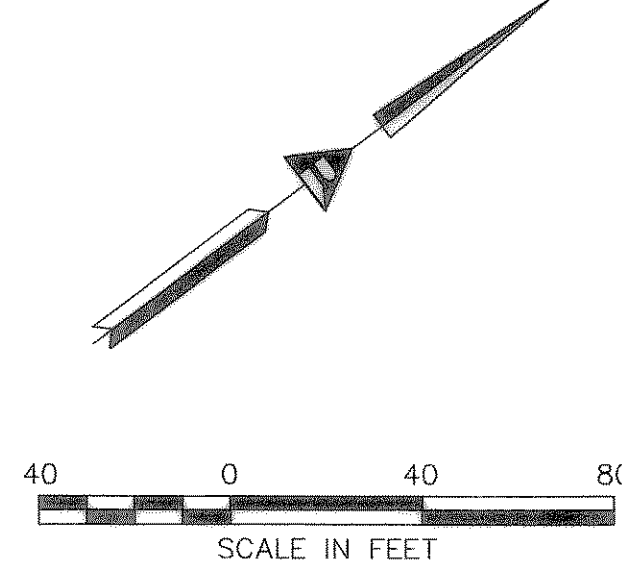
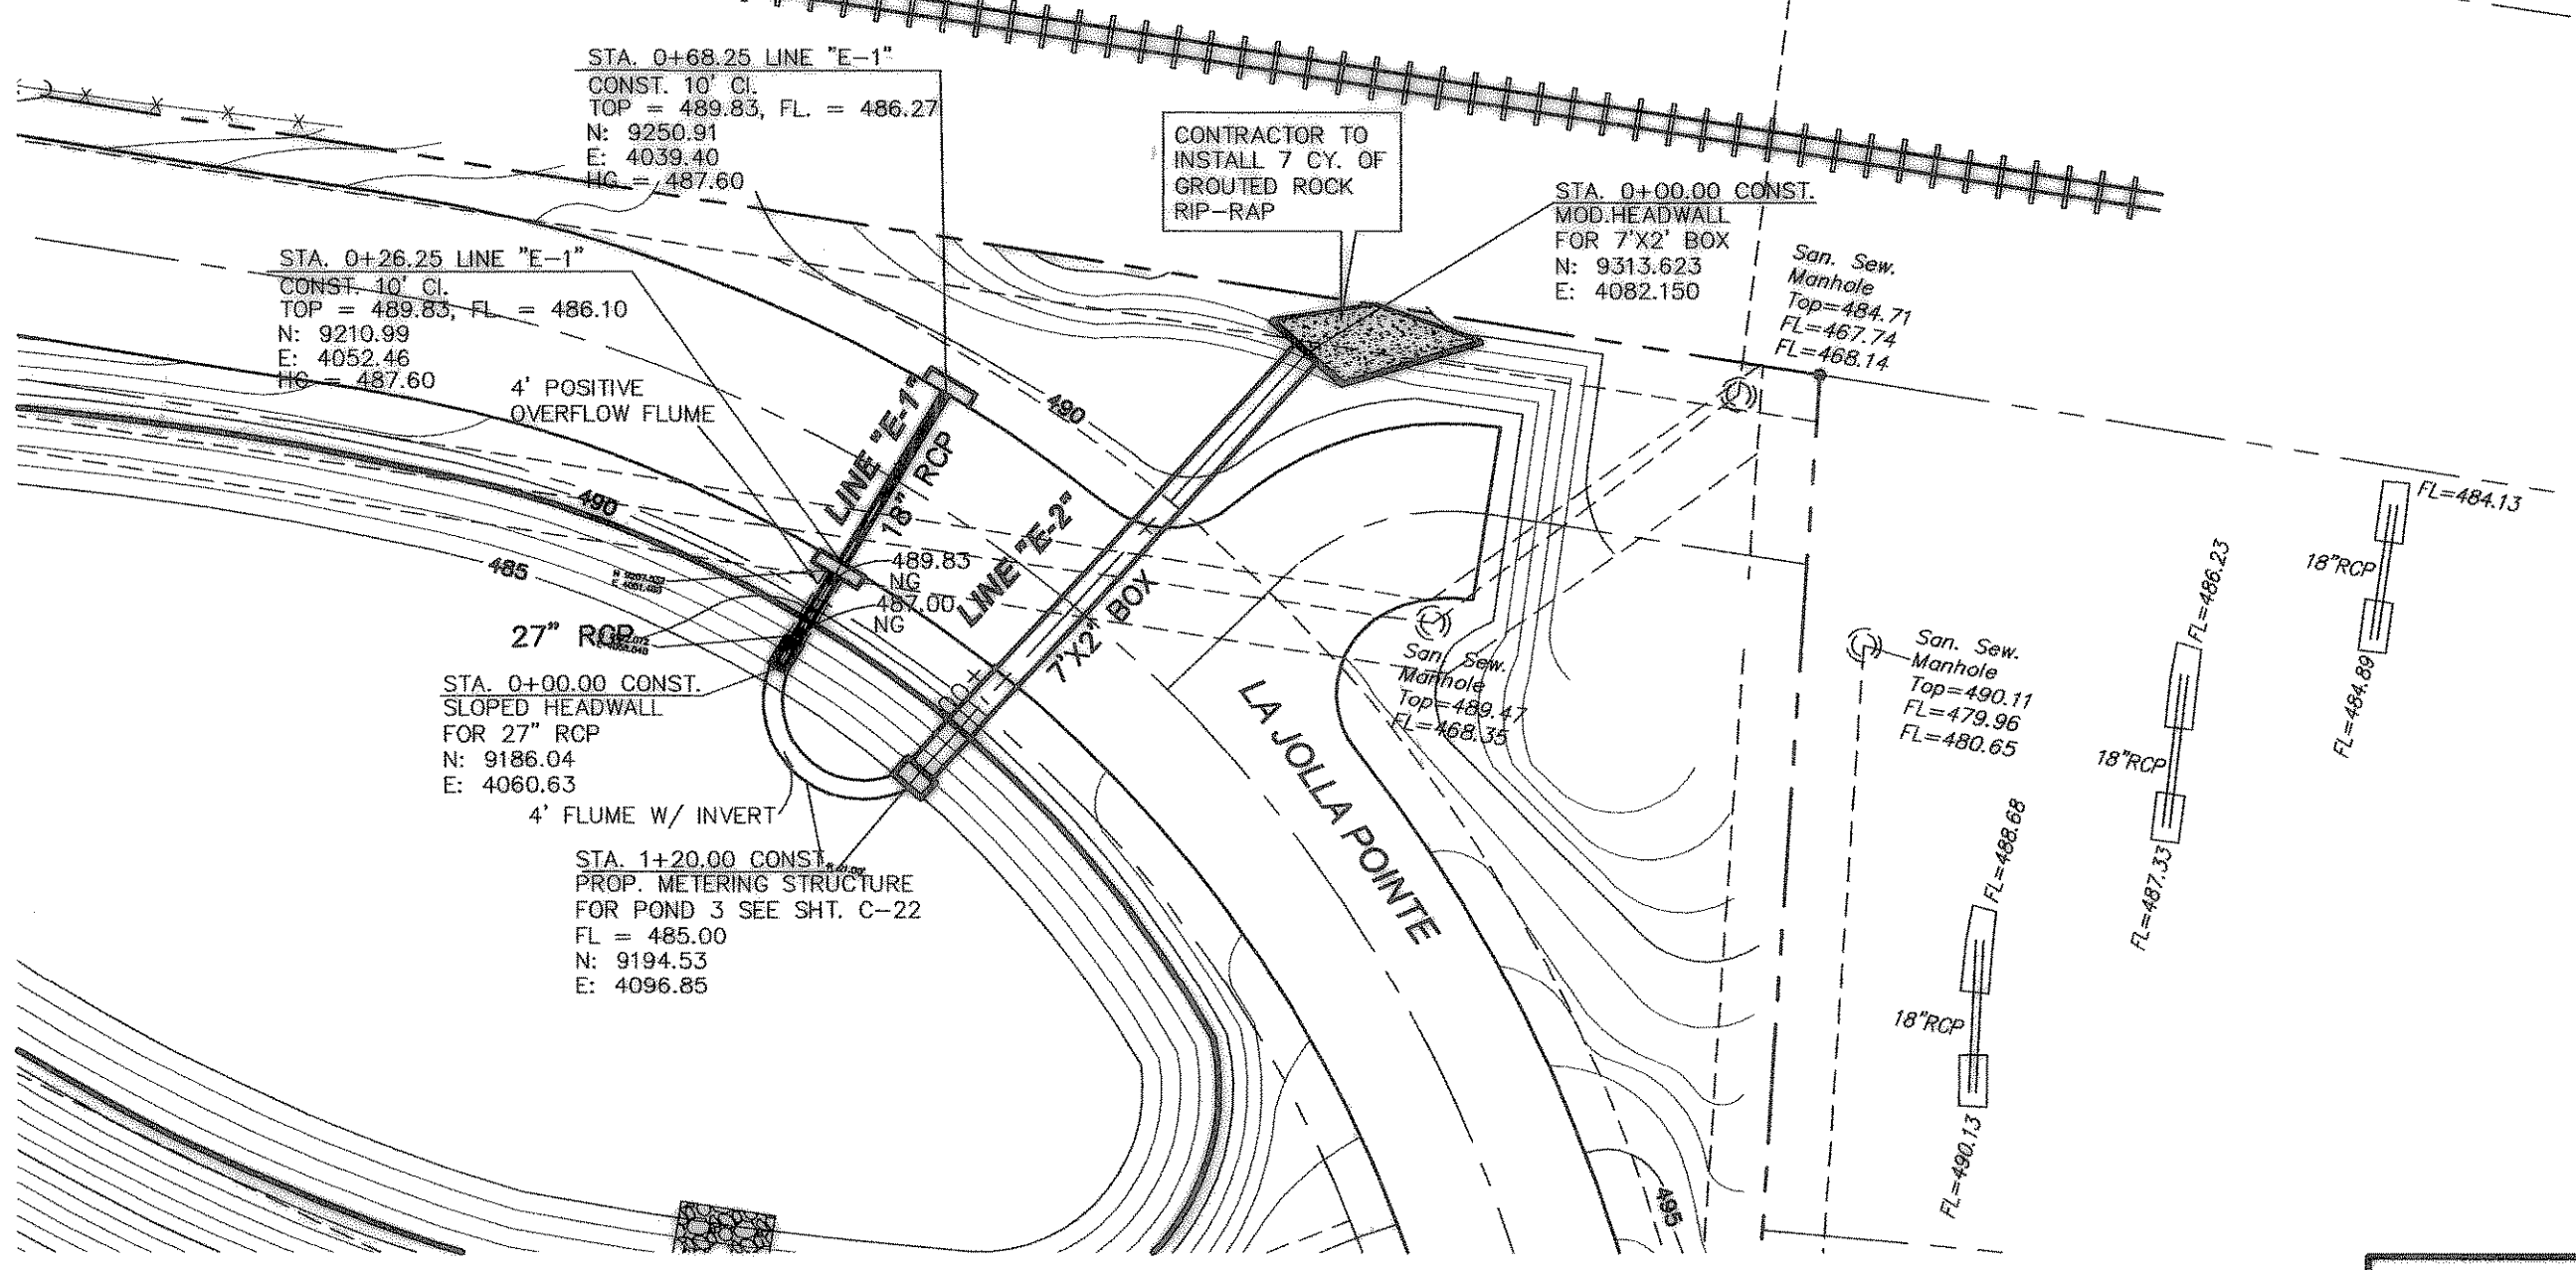


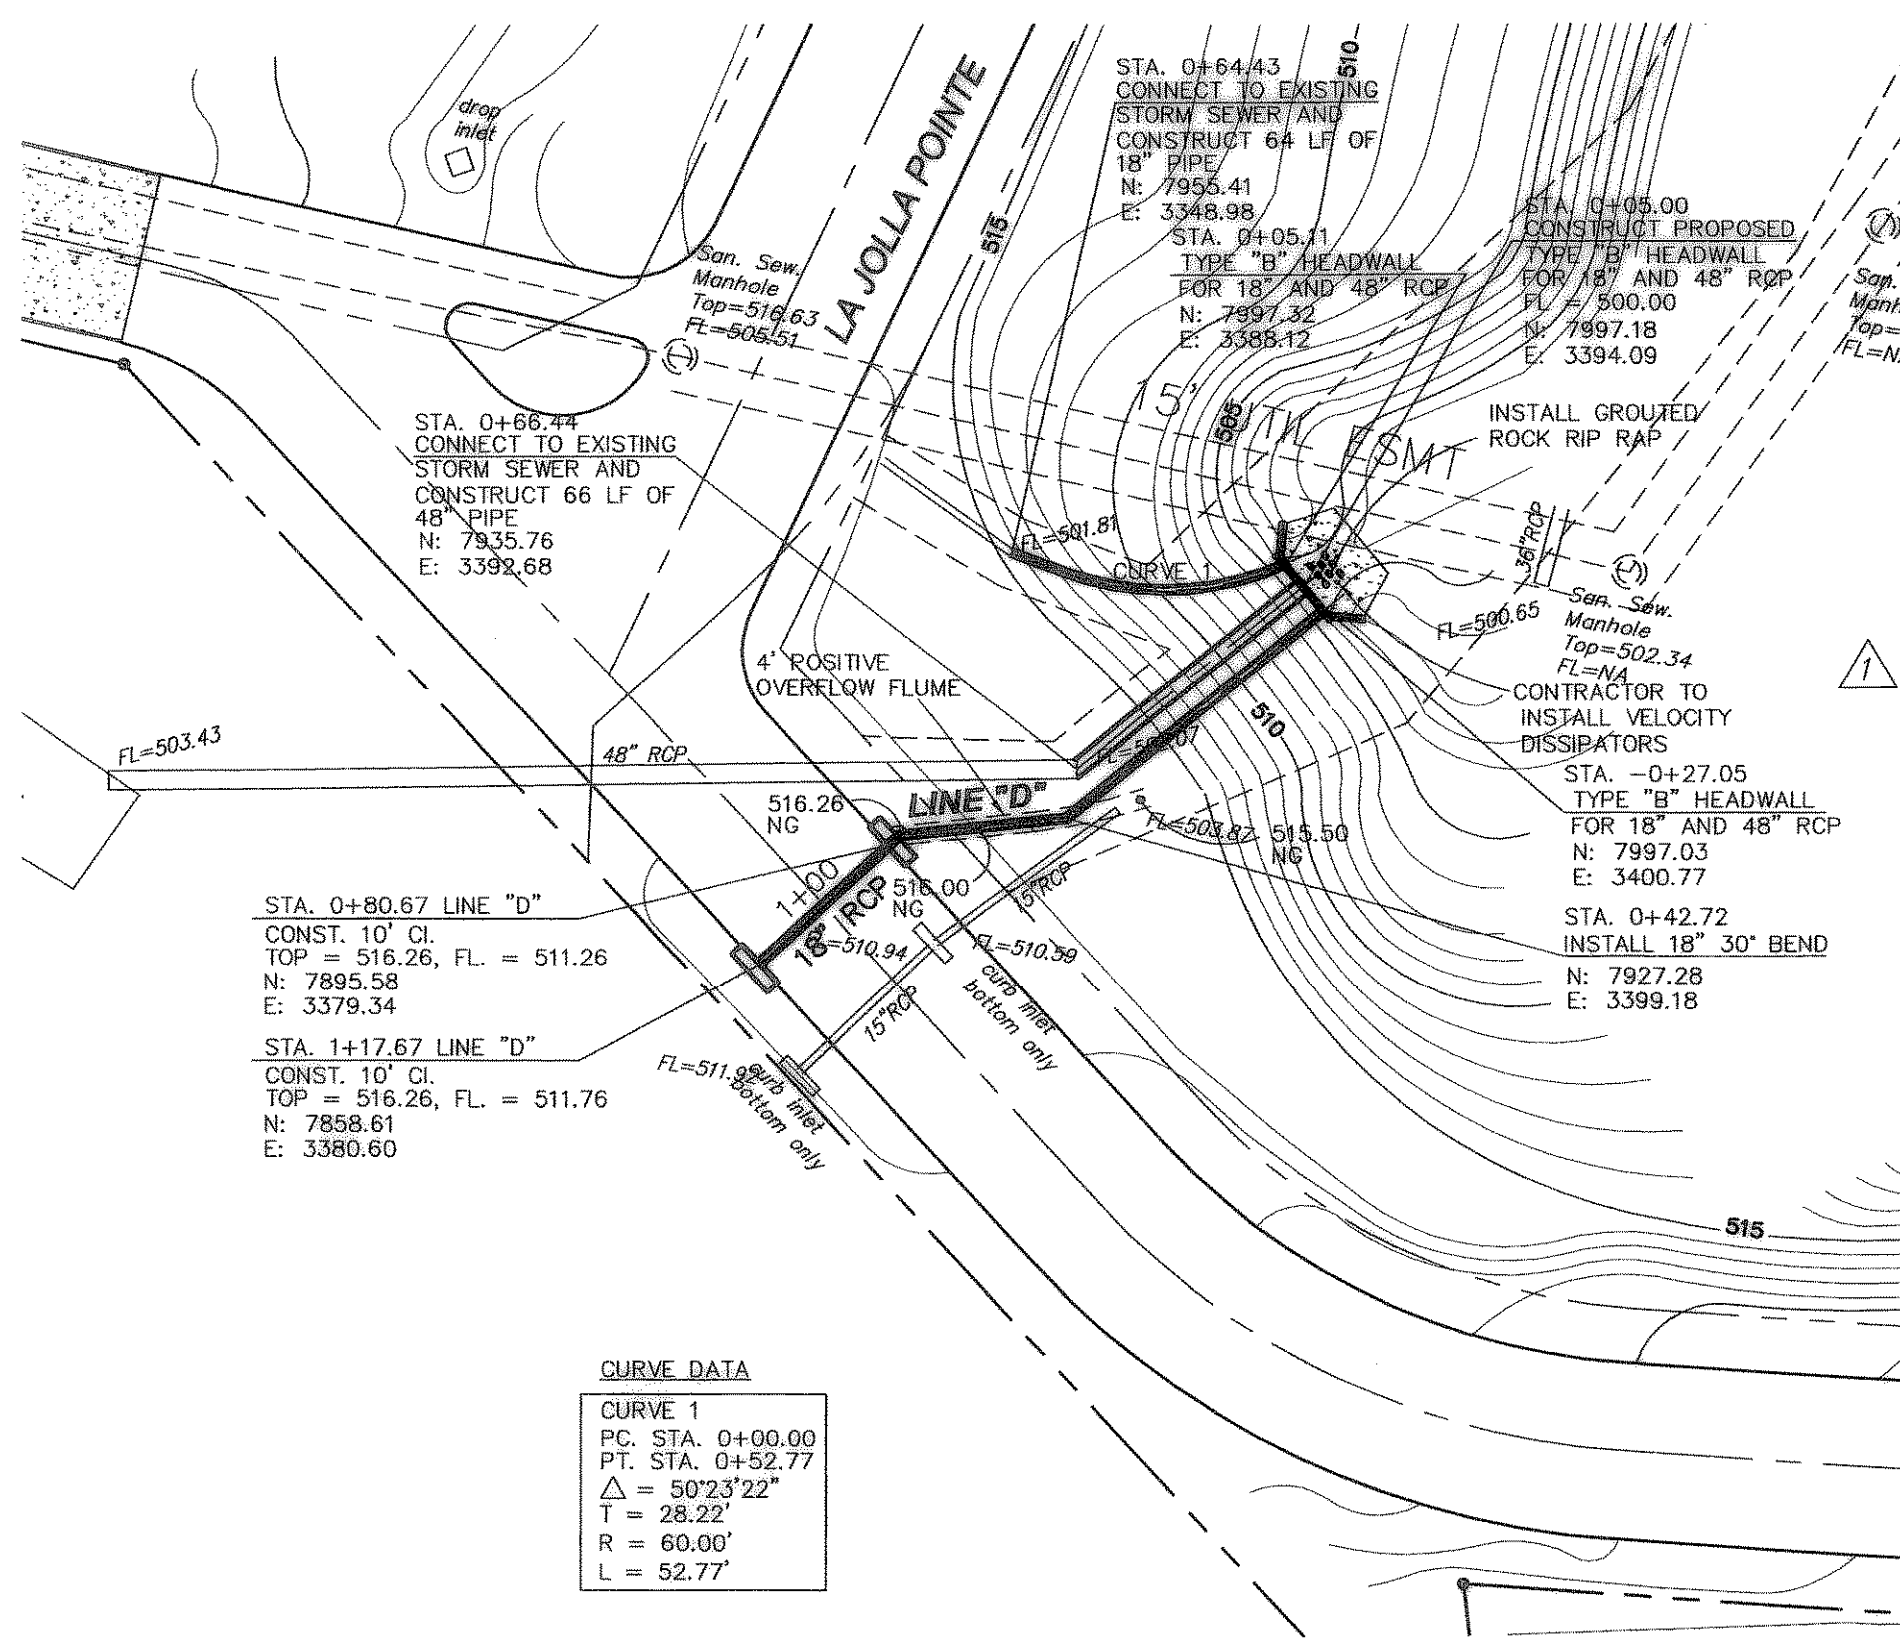


RECORD DRAWINGS
AS PROVIDED BY:
I.C.S. COMMERCIAL
Michael S. Allen
MICHAEL S. ALLEN, P.E.
DATE: 7/25/03

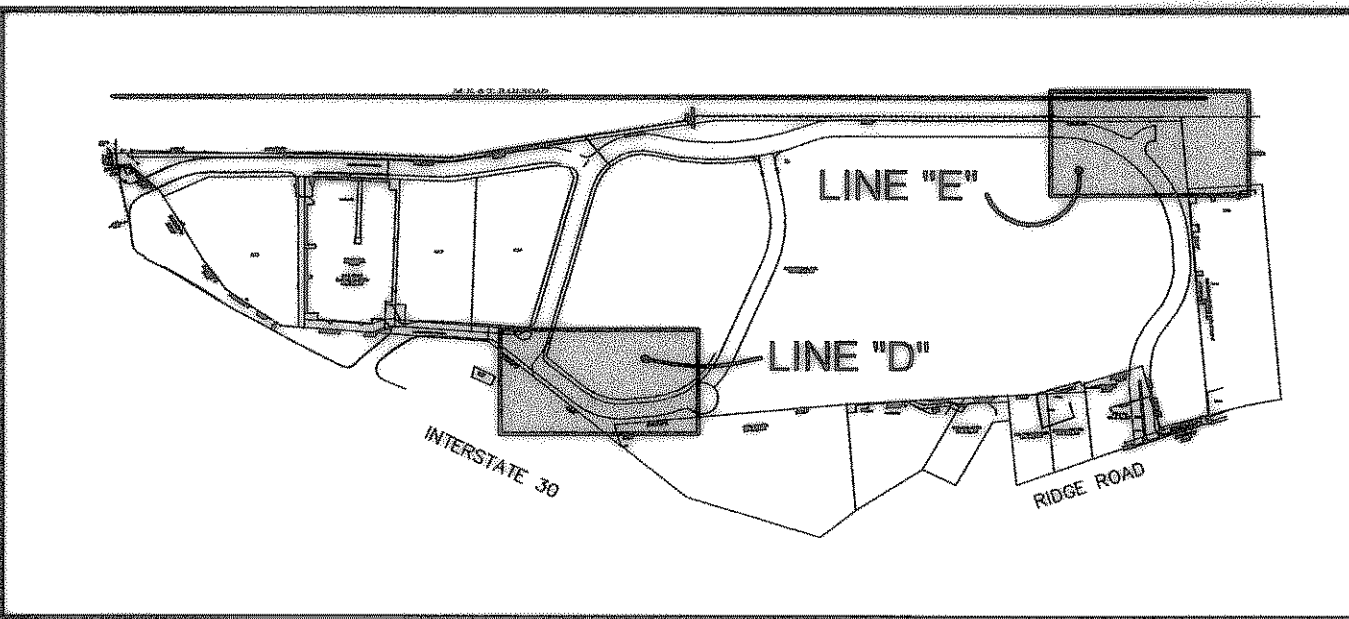

STORM SEWER LINE "D"

MISC. STM. SEW. EXTS.

STORM SEWER LINES "E-1" & "E-2"

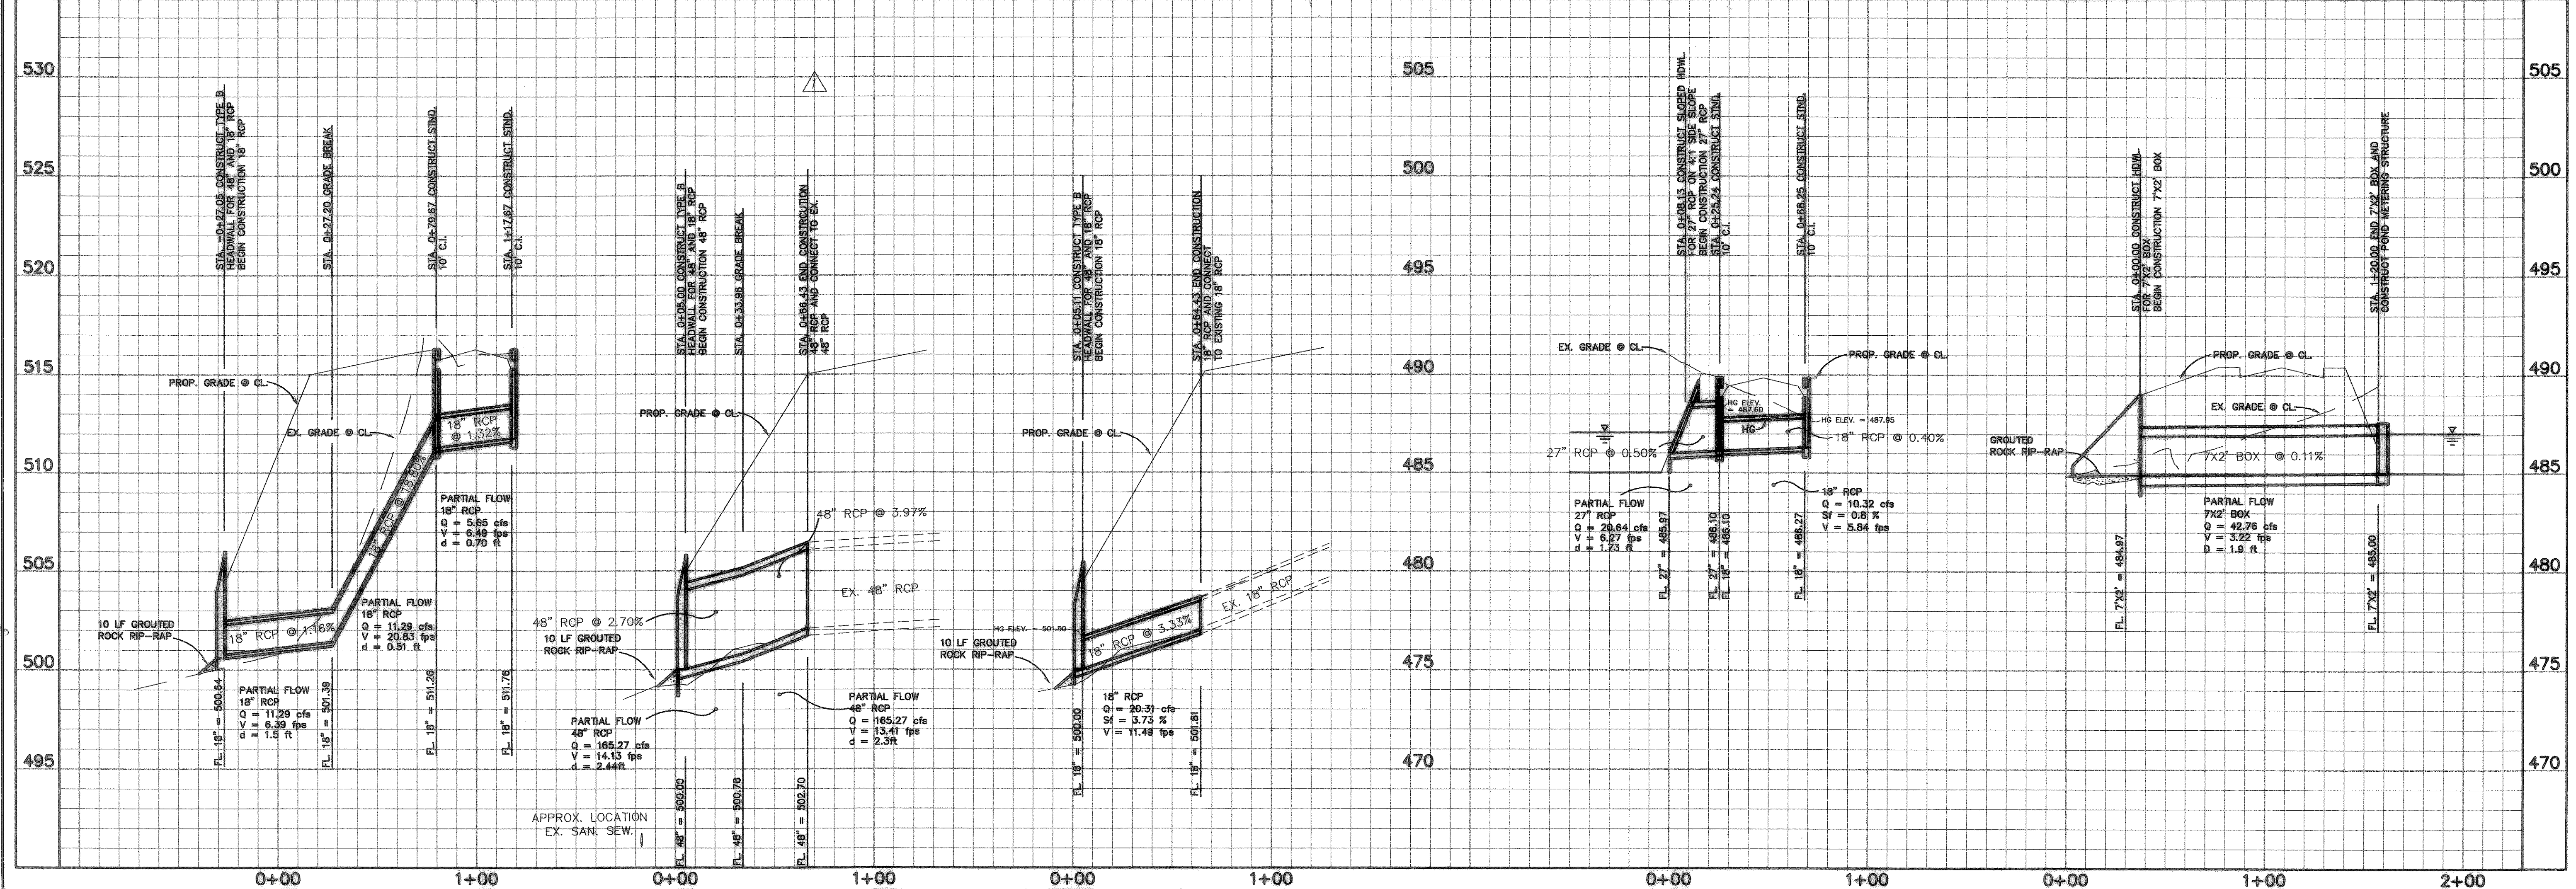

MSA		App.
5/15/03 EXTENDED STM. SEW. 27" & "Misc."		Revisions
No.	Date	

Allen & Ridinger Consulting, Inc.
109 W. Main Street
Lawville, Texas 75057
Tel. No. (972) 353-5800
Fax No. (972) 353-5801

Michael S. Allen
5/15/03

La Jolla Pointe Addition
ROCKWALL, TEXAS

STORM SEWER PLAN AND PROFILE
LINE "D", LINE "E-1" & LINE "E-2"
STA 0+00 TO END

Scale: 1"=40' HOR., 1"=4' VERT.
Designed by: MSA
Drawn by: MSA
Checked by: MSA
Date: April 1, 2003
Project No. 01B-001

SHEET
C-10
OF 25