
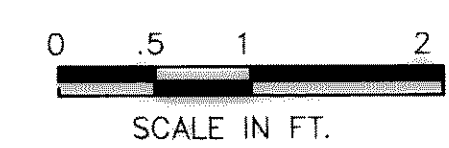


**DETAIL A - ALUMINUM PLATE WITH TELEMTRY EQUIPMENT**

NOT TO SCALE

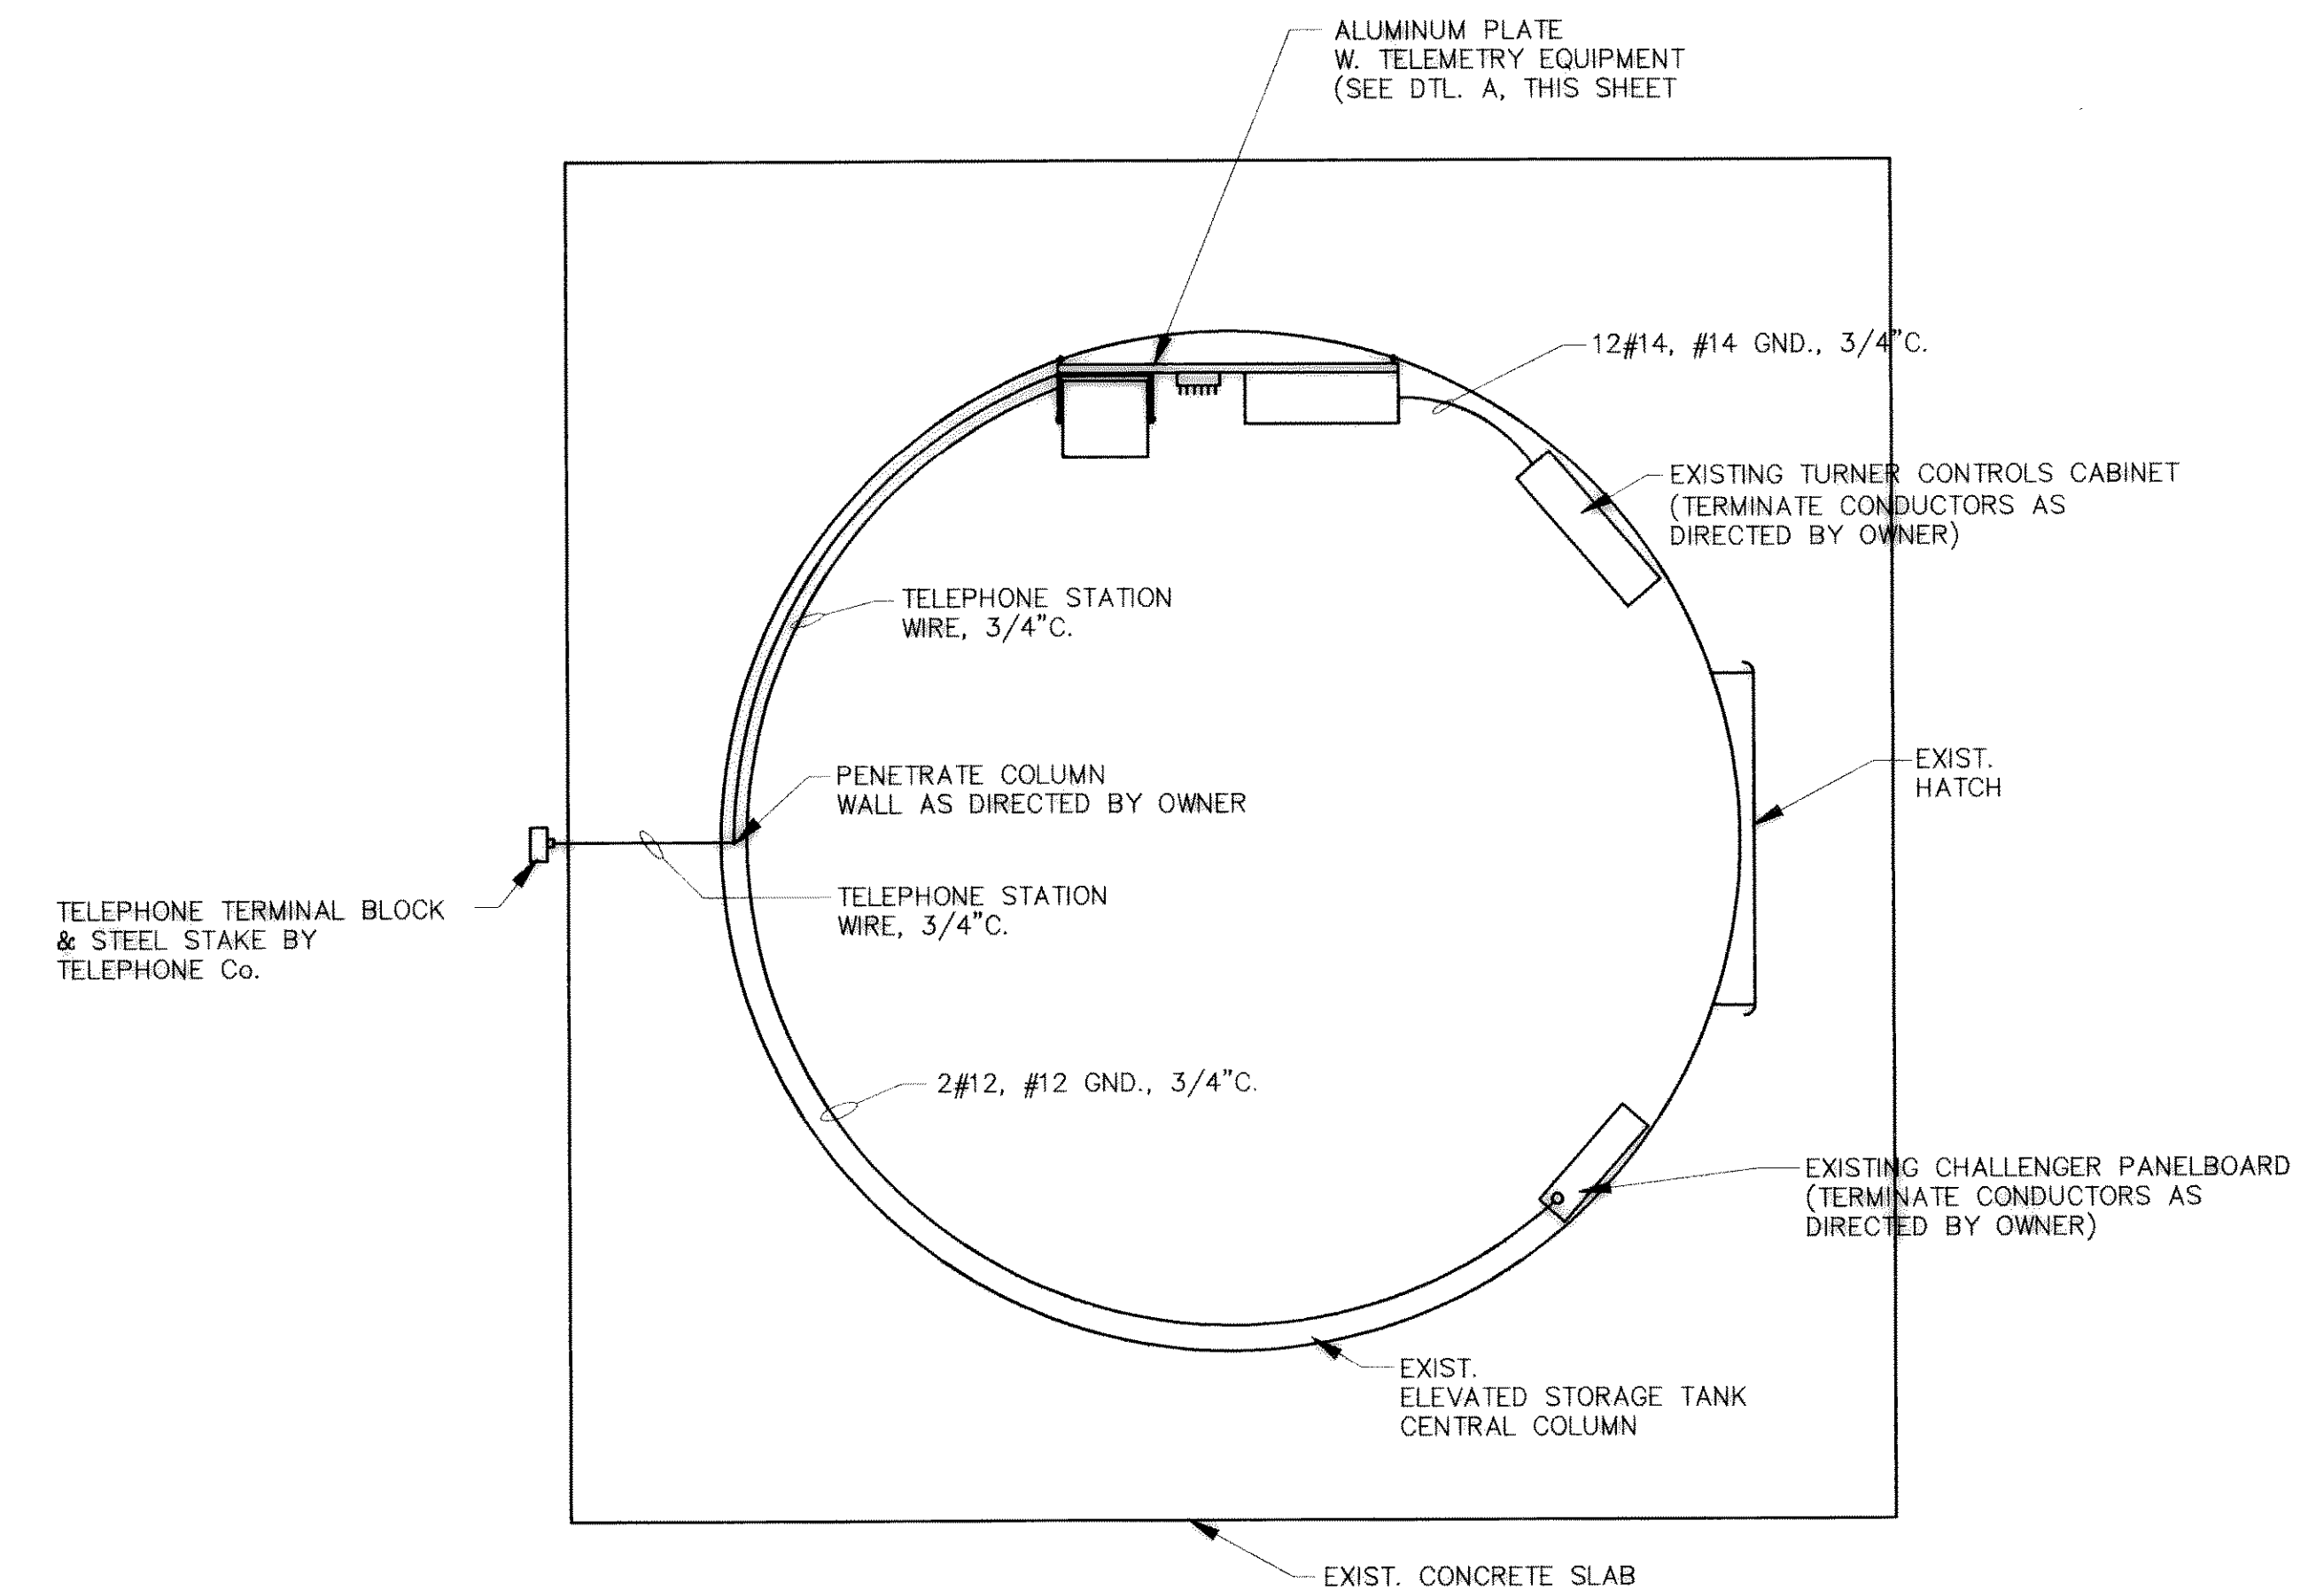

**ELEVATED STORAGE TANK CENTRAL COLUMN ELECTRICAL AND COMMUNICATION PLAN**

REFER TO GARICO, INC. JOB. No. 9114 DWGS 01,02,03 & 04 FOR CHANGES TO THIS SHT.



**RECORD DRAWING**  
 BASED ON INFORMATION  
 SUPPLIED BY THE CONTRACTOR  
 DATE: 12/17/92 BY: MAC

ACAD File 12 User: Hugo Trevino  
 N:\RESTORE\ELET\ROKDWG37.DWG  
 DEC 28, 1992 1:36:24 P.M.

12/17/92	RECORD DRAWINGS FURNISHED BY CONTRACTOR	MAC	DESIGNED: _____	JOB NO. ROK89005	FREESE AND NICHOLS, INC. CONSULTING ENGINEERS FORT WORTH - ARLINGTON - AUSTIN, TEXAS	CITY OF ROCKWALL, TEXAS EASTSIDE PUMP STATION	ELECTRICAL EXISTING ELEVATED TANK	SHEET 37 OF 39
		DRAWN: _____	DATE 11/8/90					
		TRACED: _____	SCALE AS SHOWN					