
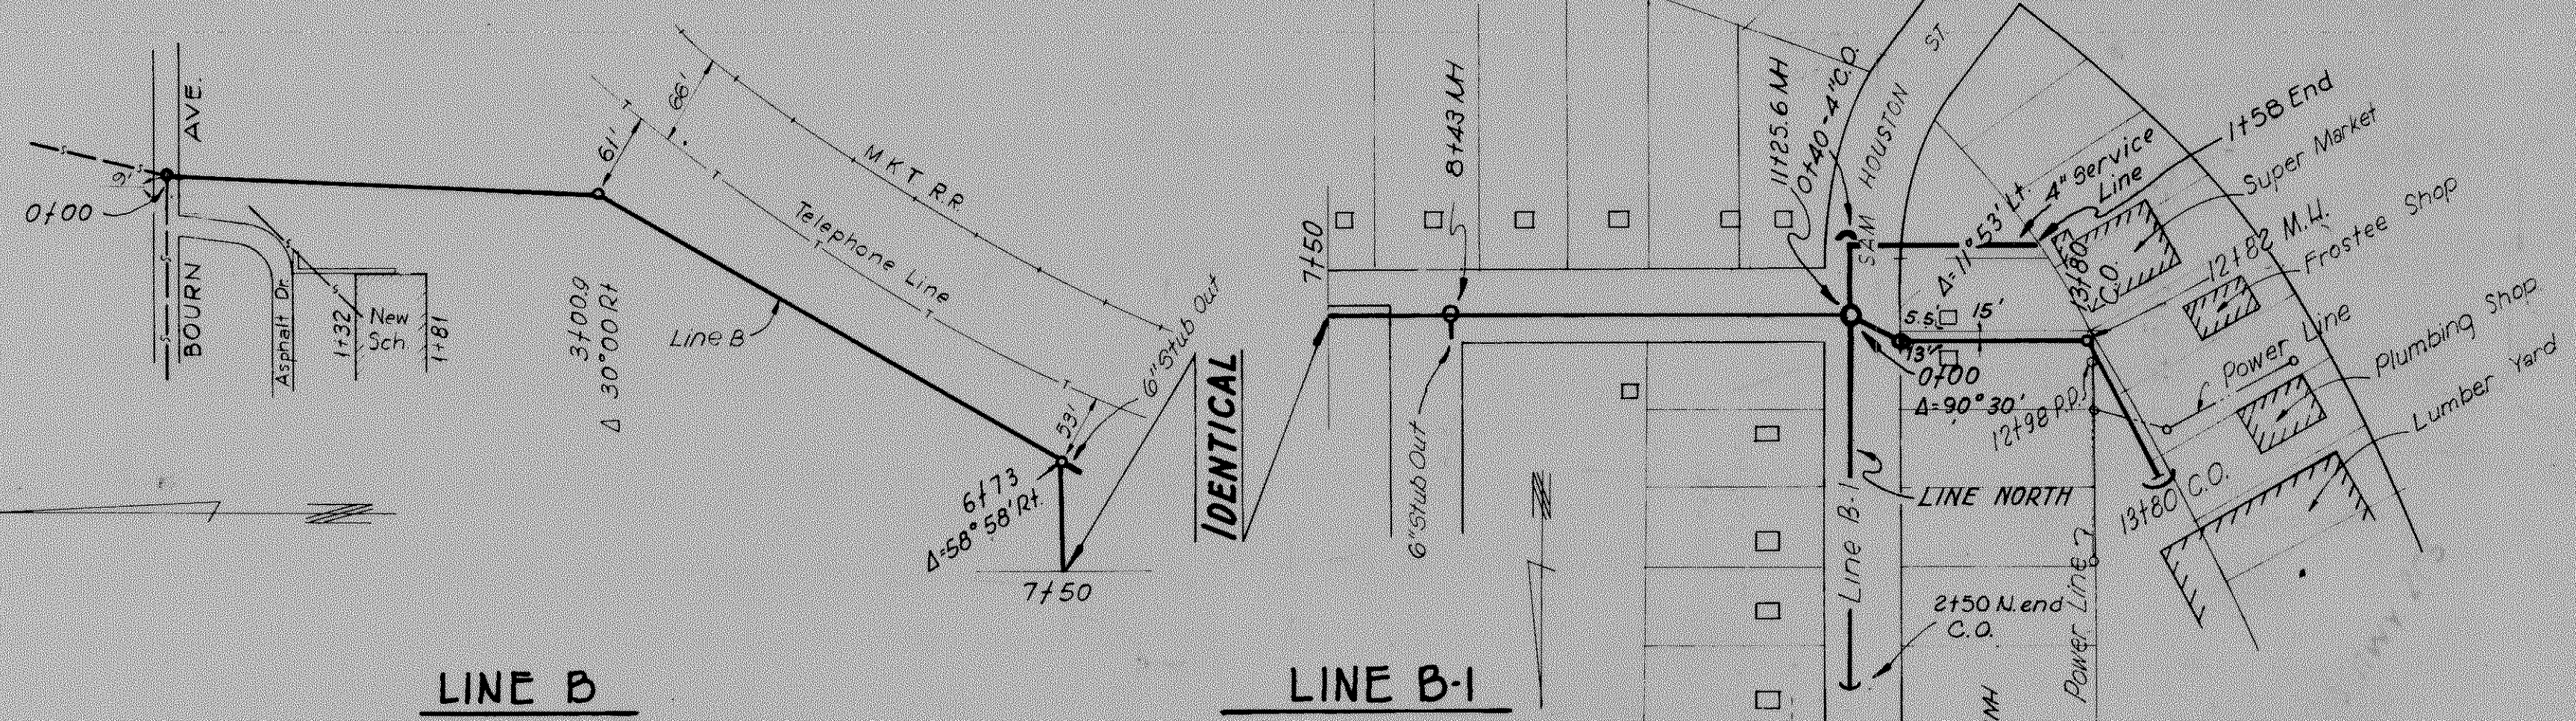


PLAN	DATE	BY	NO.
SURVEYED			
NOTE BOOK			
ALIGNMENT CHECKED			
RT. OF WAY CHECKED			

PROFILE	DATE	BY	NO.
SURVEYED			
NOTE BOOK			
STRUCTURE NOTATIONS CHKD			


LINE E-1
For Profile See
Sheet 4

LINE E

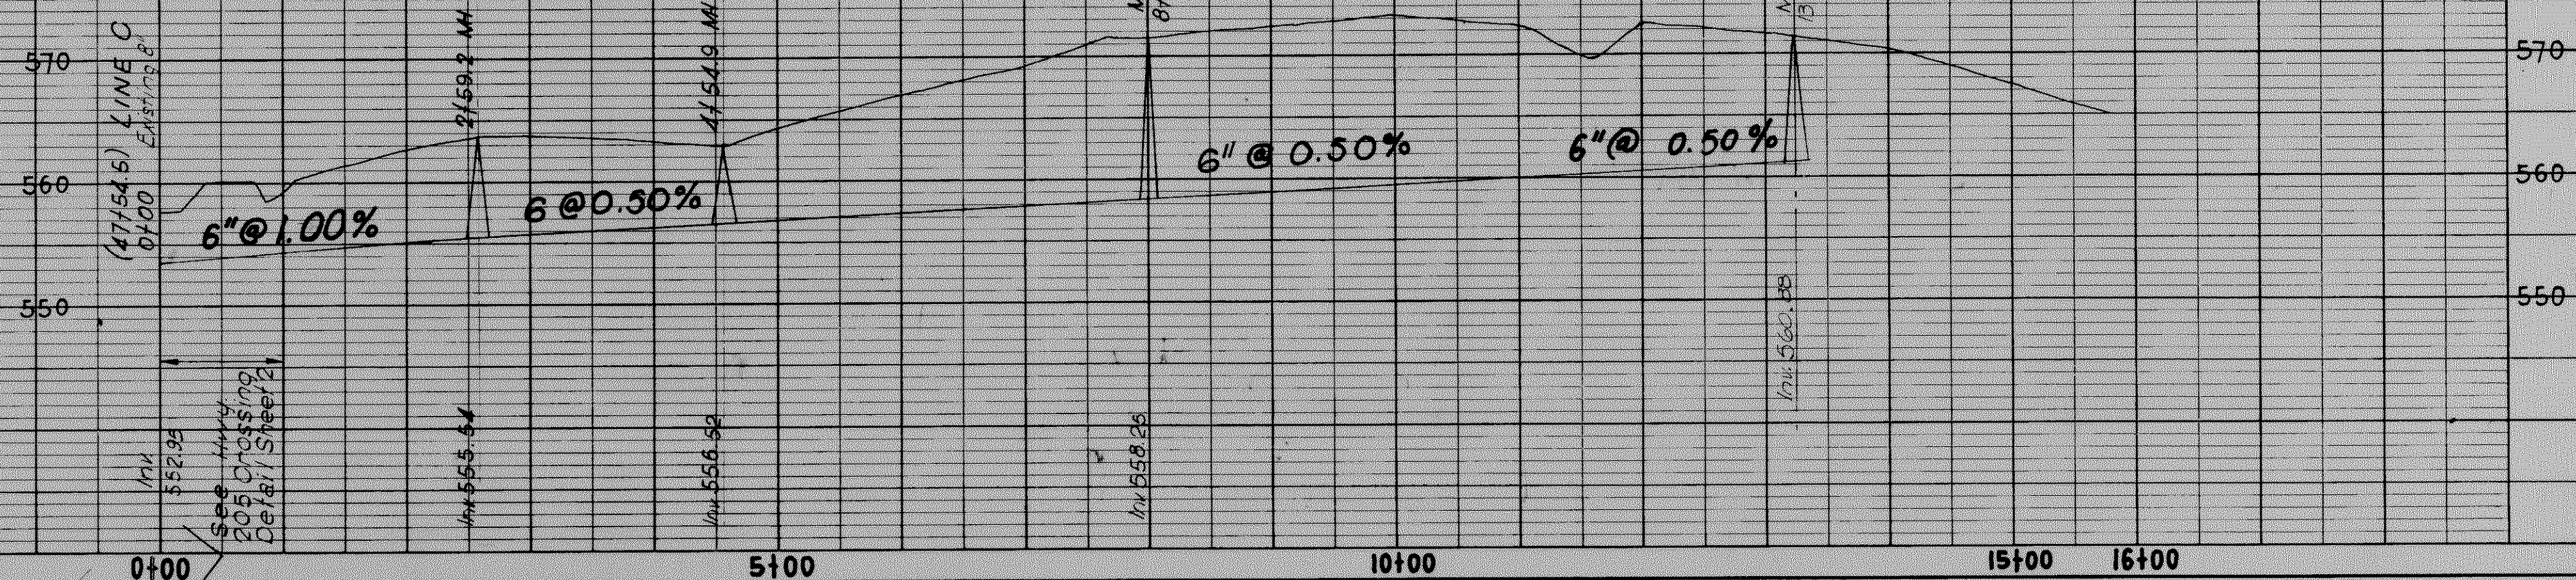

LINE B

LINE B-1

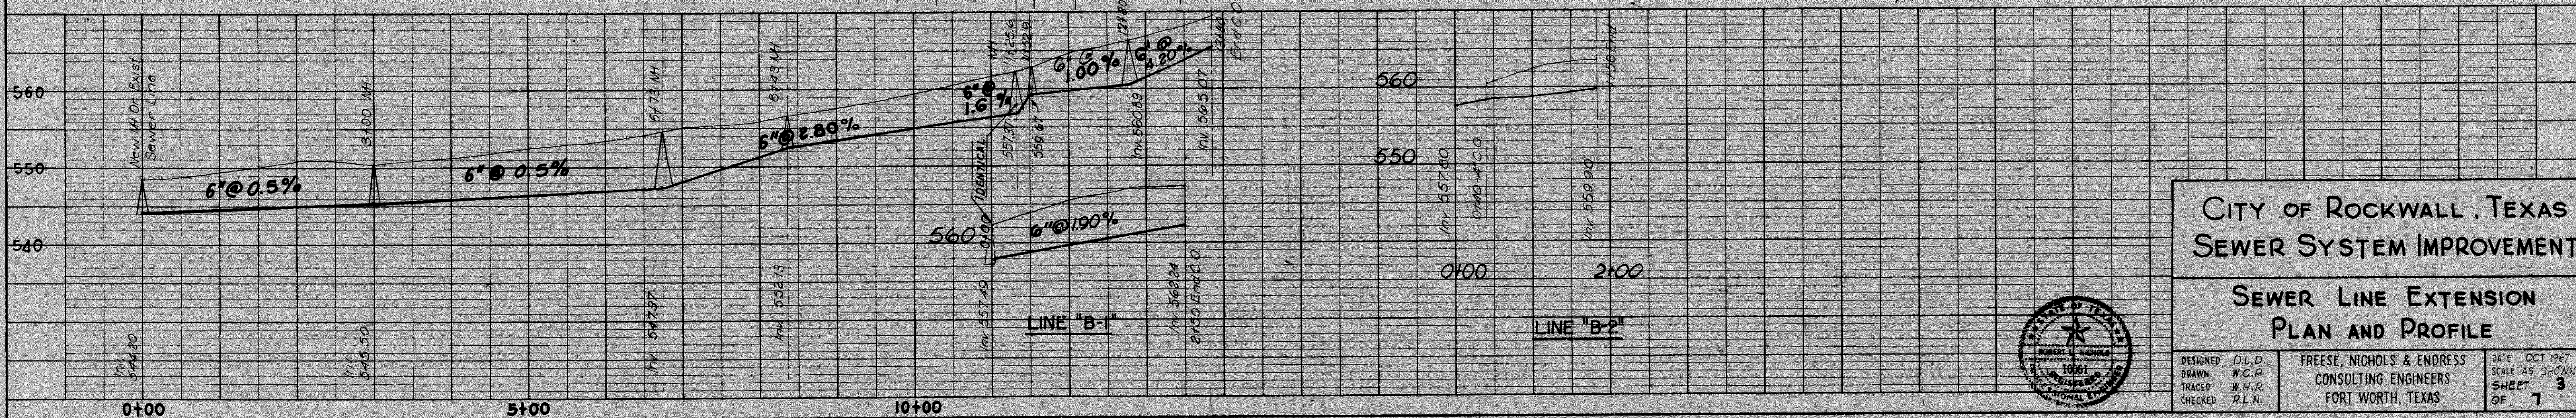

LINE "B-1"

LINE "B-2"

REVISED AS
DATE Sept 1969

NOTE:
Contractor shall verify location
and elevation of all Utility Lines.

CITY OF ROCKWALL, TEXAS
SEWER SYSTEM IMPROVEMENT

SEWER LINE EXTENSION
PLAN AND PROFILE

DESIGNED D.L.D.	FREESE, NICHOLS & ENDRESS	DATE: OCT. 1967
DRAWN W.C.P.	CONSULTING ENGINEERS	SCALE: AS SHOWN
CHECKED R.L.N.	FORT WORTH, TEXAS	SHEET 3

