




City of Rockwall


Planning & Zoning Department
385 S. Goliad Street
Rockwall, Texas 75032
(P): (972) 771-7745
(W): www.rockwall.com

The City of Rockwall GIS maps are continually under development and therefore subject to change without notice. While we endeavor to provide timely and accurate information, we make no guarantees. The City of Rockwall makes no warranty, express or implied, including warranties of merchantability and fitness for a particular purpose. Use of the information is the sole responsibility of the user.

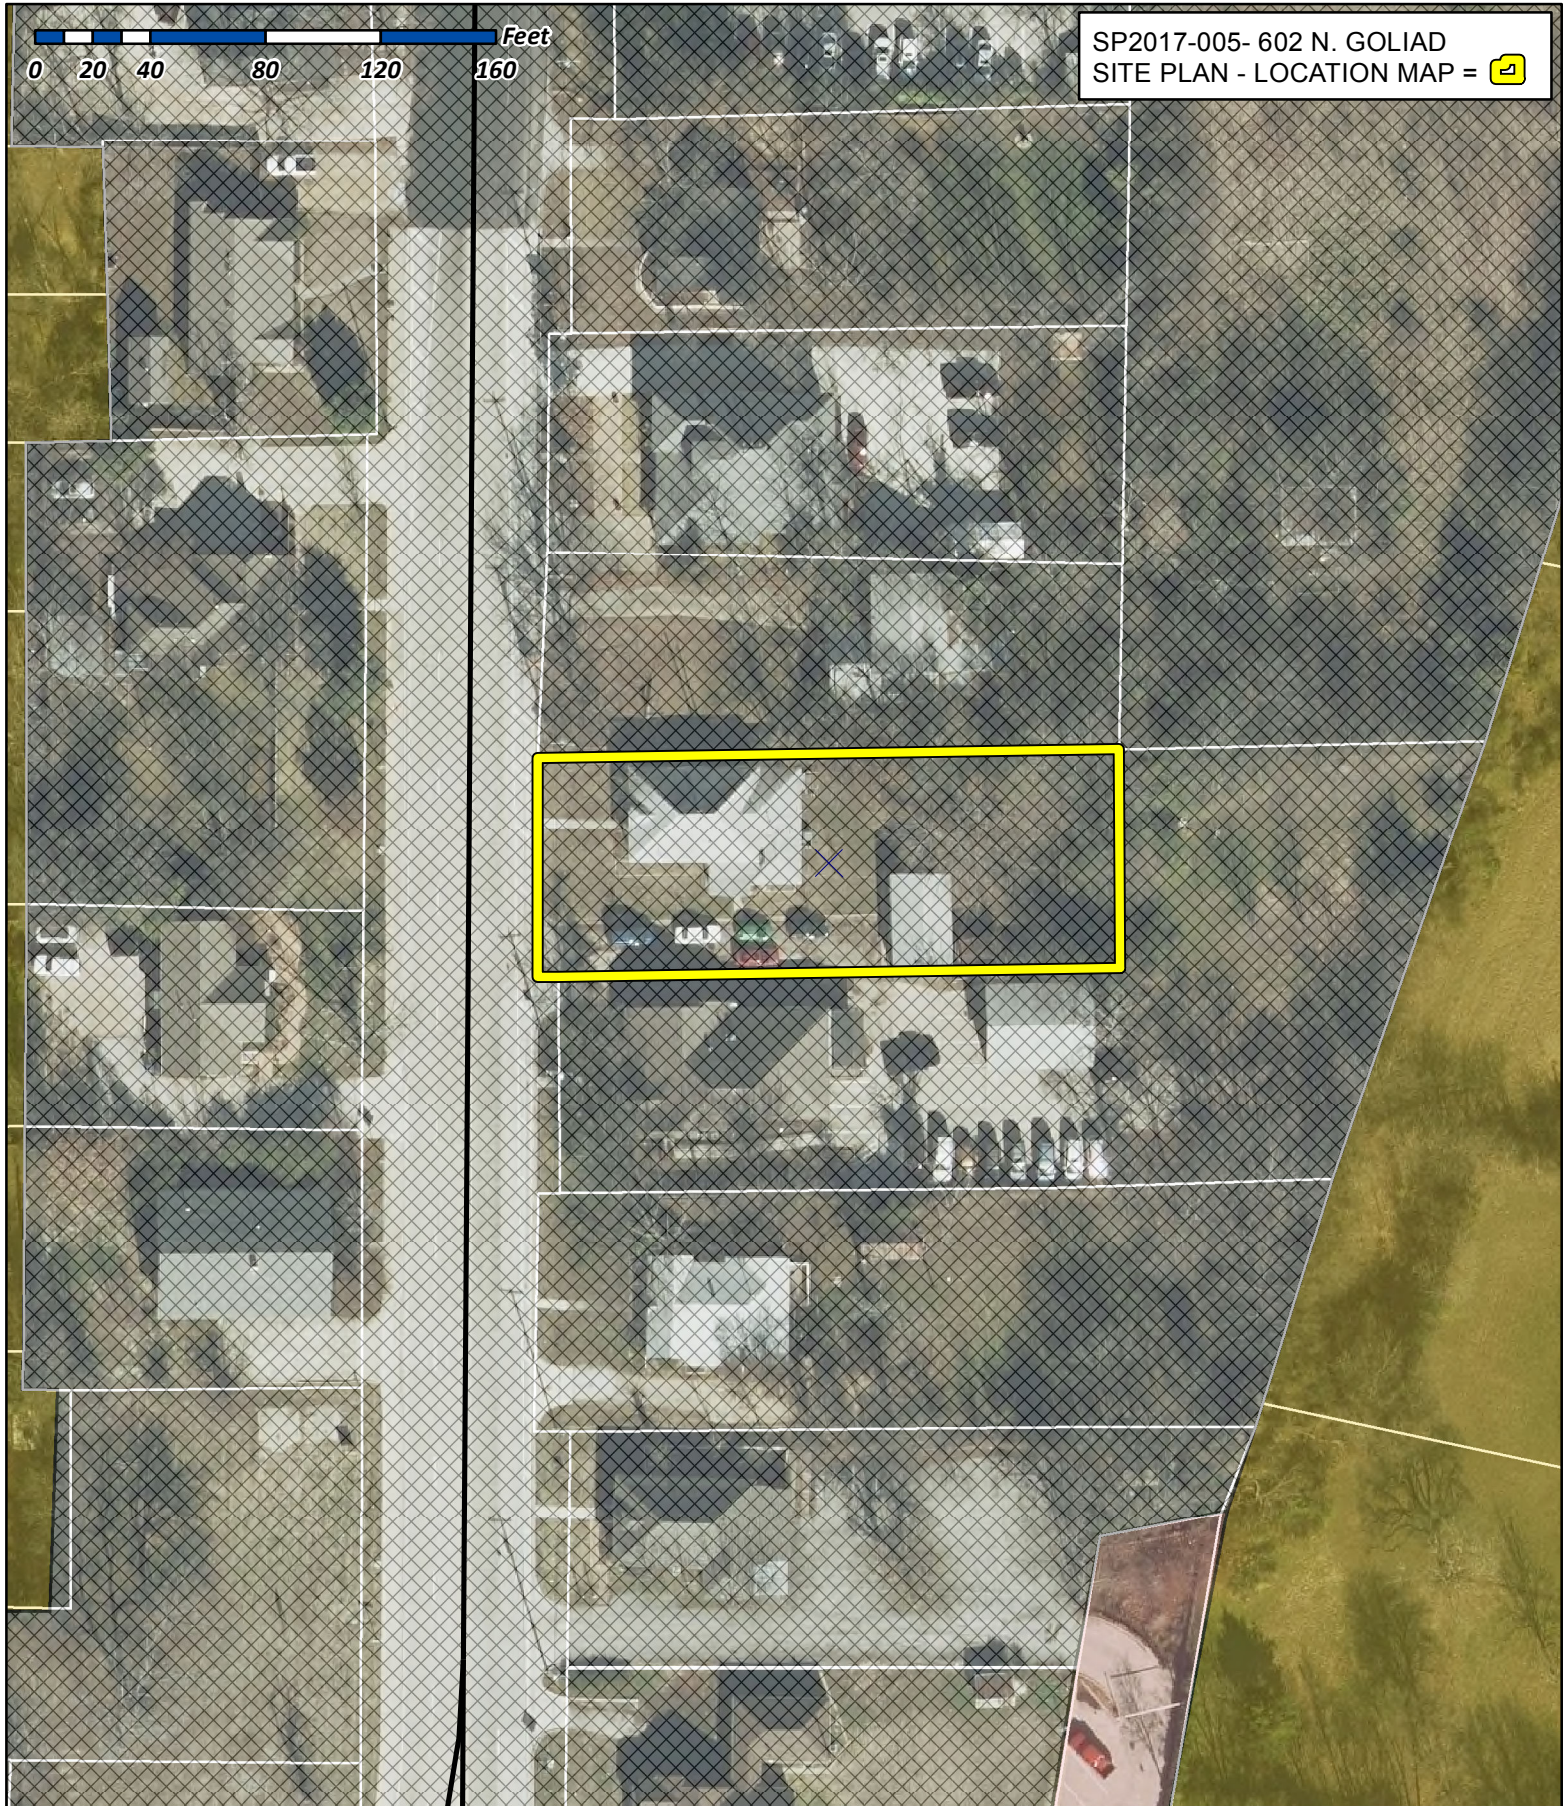



N. GOLIAD STREET
(STATE HIGHWAY 205)
VARIABLE WIDTH R.O.W.

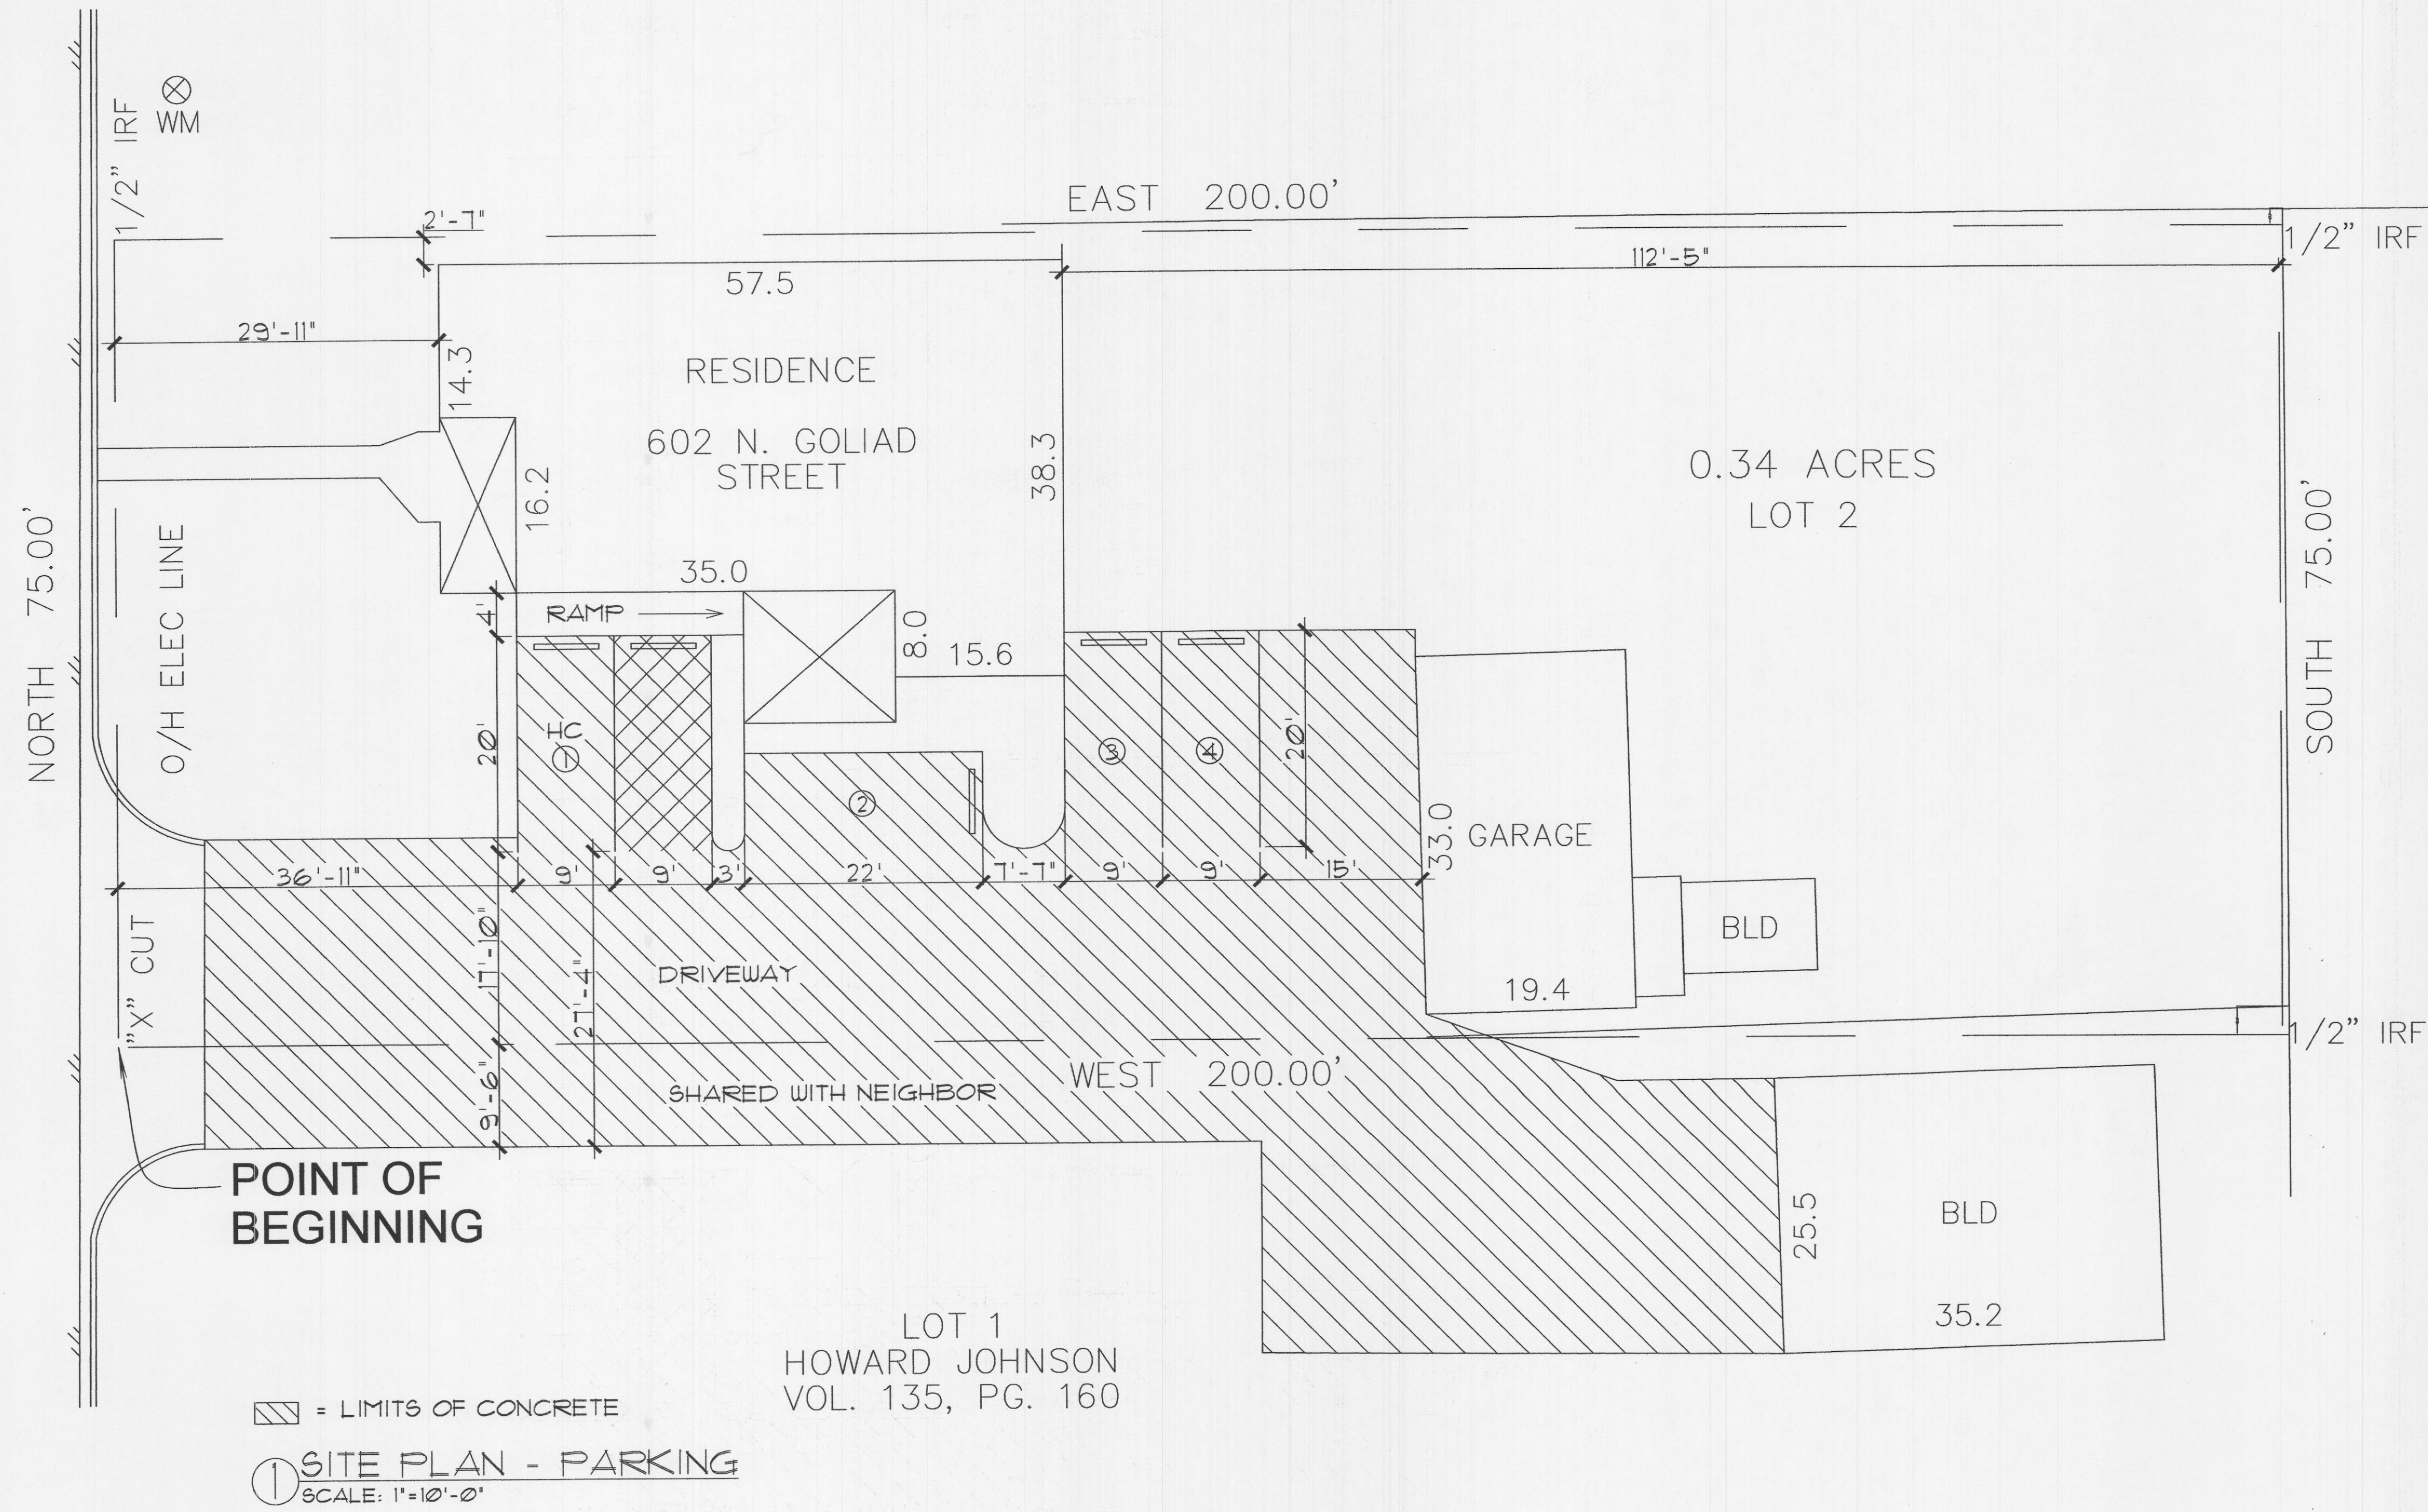

ROCKWALL
FREE CLINIC
602 NORTH GOLIAD
ROCKWALL, TEXAS 75087

TITLE: SITE PLAN - PARKING

SCALE:
AS SHOWN

SHANNON NEWCOM MARK NEWCOM
CADAZIGN
3709 C.R. 2522
ROYSE CITY, TEXAS 75189
409-338-9863

DATE _____

11/08/16


REVISION DATE:

SHEET



JOB NO.

18516CAD

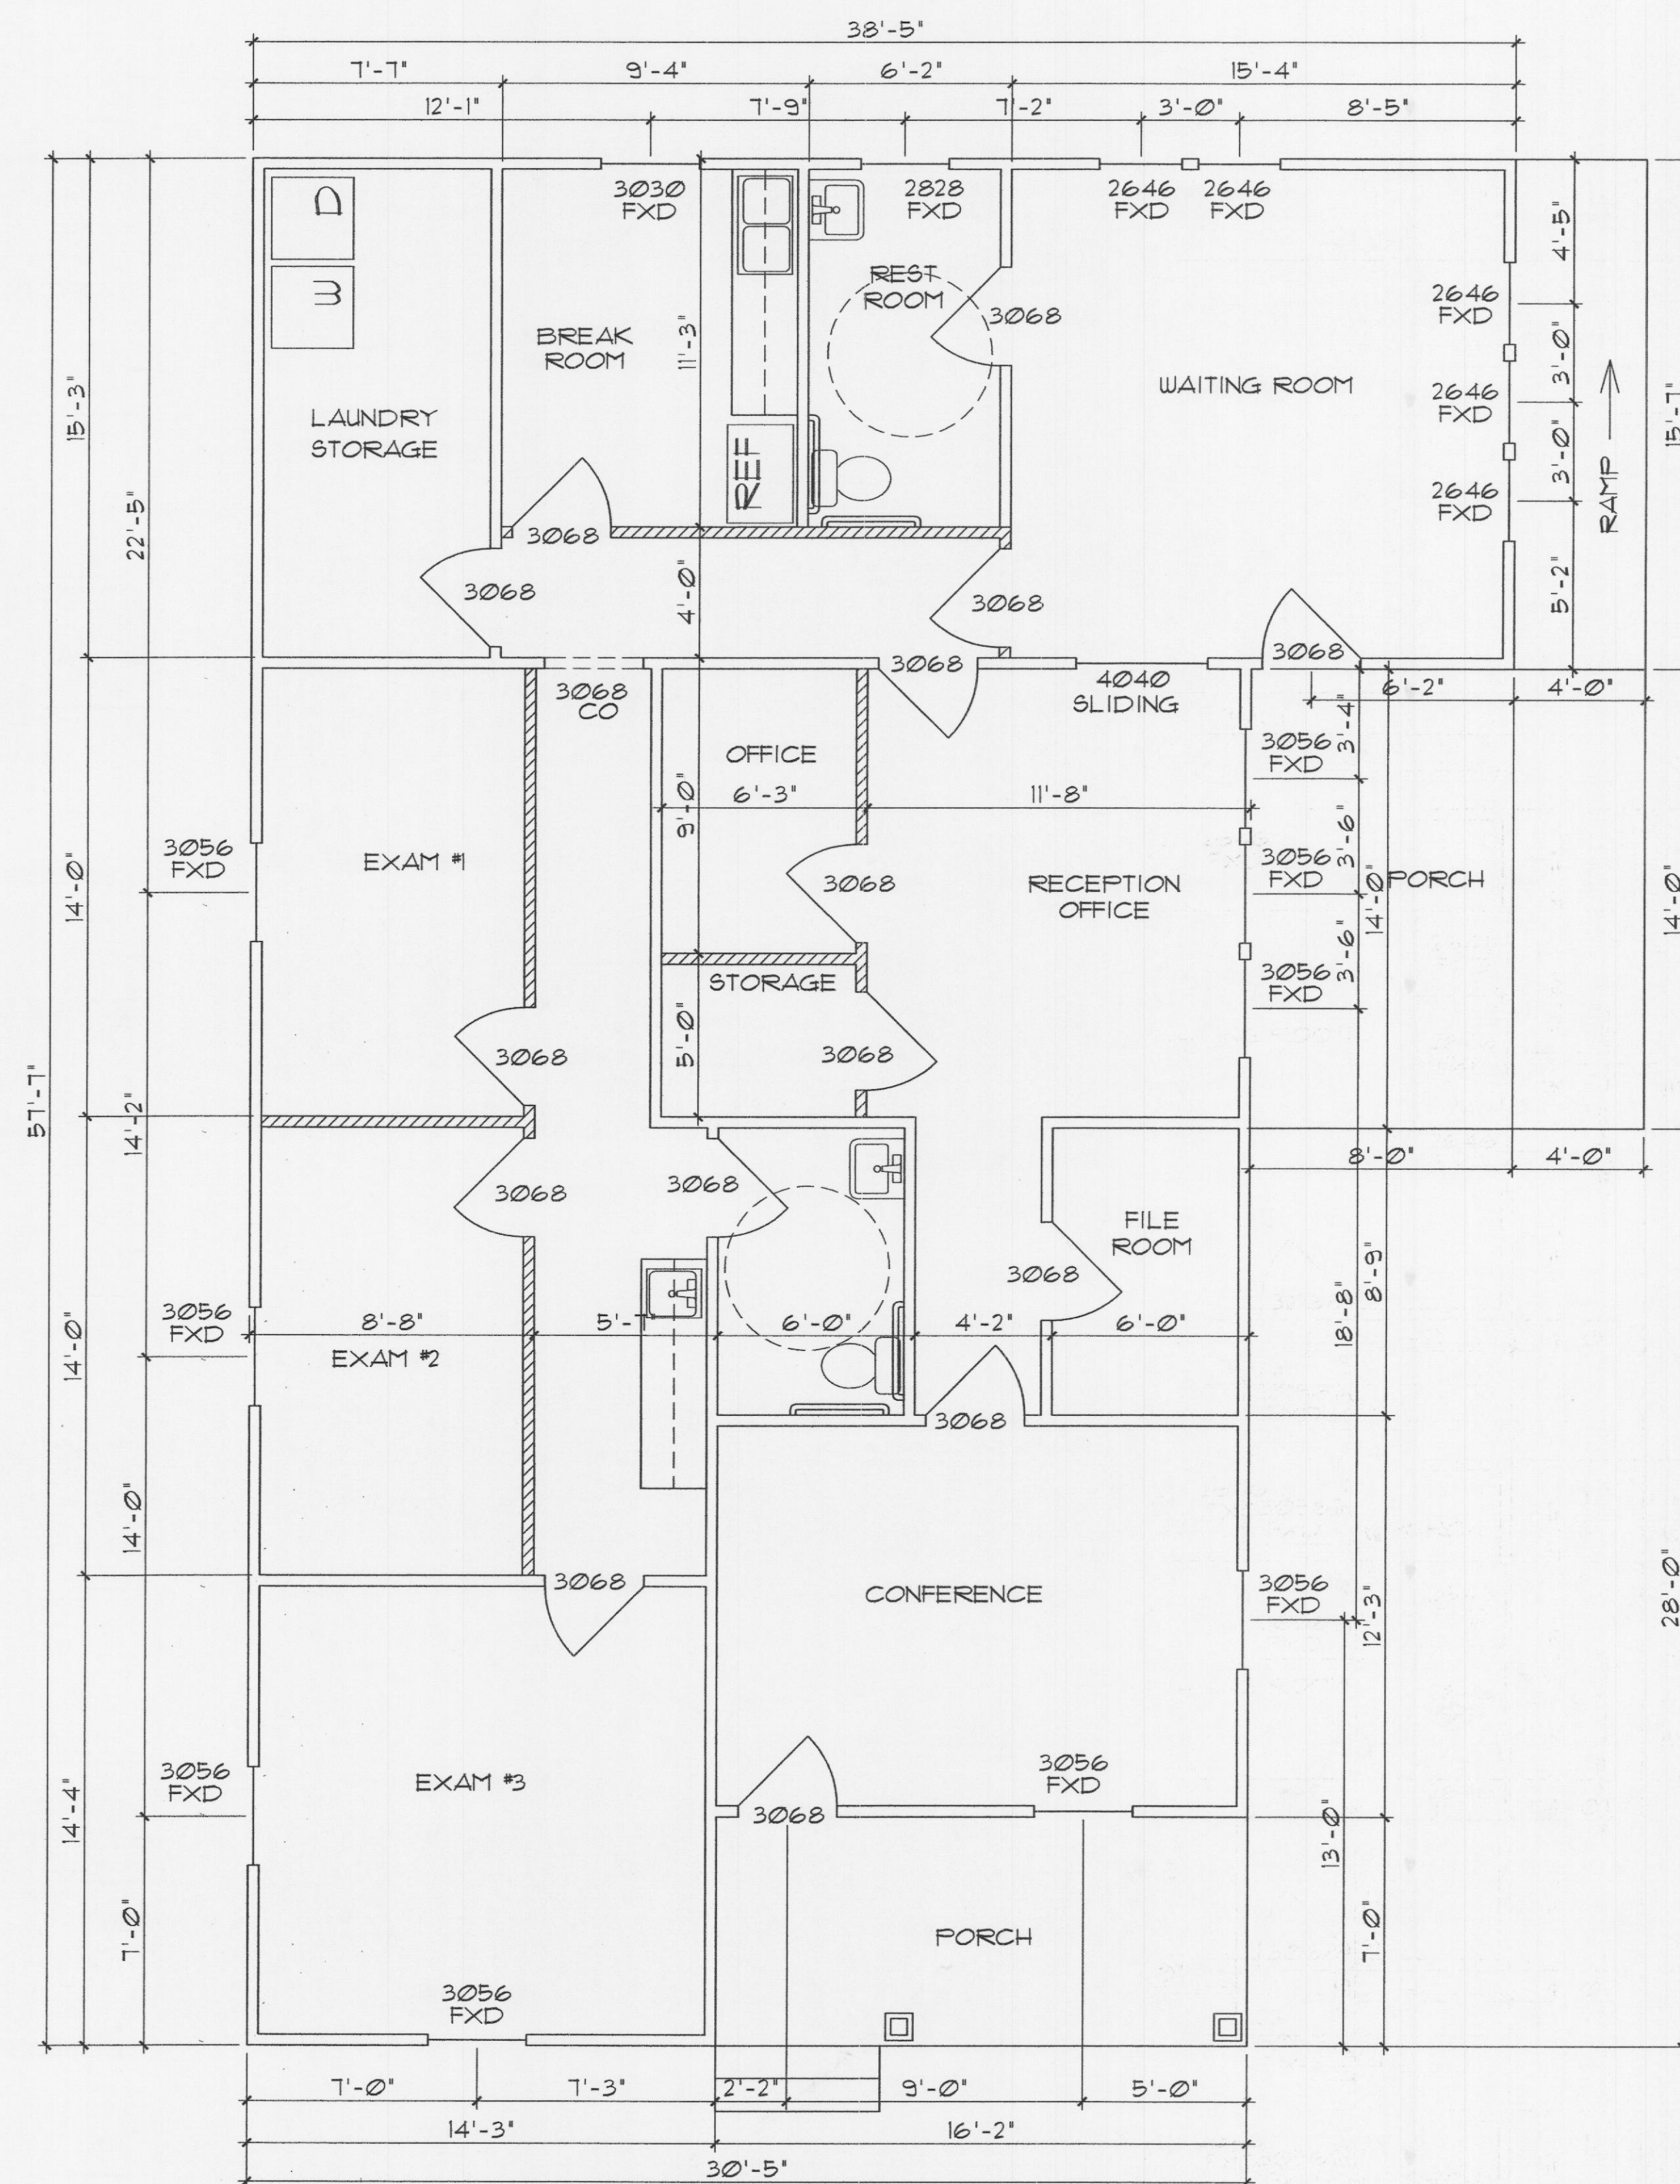


ELECTRICAL LEGEND

\$	SWITCH
\$D	SWITCH W/ DIMMER
\$3	SWITCH - 3 WAY
110	OUTLET
110 FP	OUTLET - FLOOR PLUG
110 WP	OUTLET - WEATHER PROOF
110 XX'	OUTLET - XX' ABOVE FINISHED FLOOR
110 GFCI	OUTLET - GROUND FAULT CIRCUIT INTERRUPT
110 CLNG	OUTLET - CEILING MOUNTED
220	OUTLET
WALL	FIXTURE
110 MP	MOISTURE PROOF FIXTURE
110	CEILING FIXTURE
110 FAN/LT	CEILING FAN W/ LIGHT
110 FAN	CEILING FAN
LED	RECESSED LED
VOICE / DATA	VOICE / DATA
EXHAUST FAN	EXHAUST FAN
DISP	DISPOSER
SMOKE	SMOKE DETECTOR
110 MOTION	MOTION SENSOR EXTERIOR LIGHTING
LANDSCAPE	LANDSCAPE UP-LIGHTS
UNDER COUNTER	UNDER COUNTER LIGHT
SPEAKER	SPEAKER
TELEVISION	TELEVISION CABLE

 = NEW CONSTRUCTION

AREAS	
A/C AREA	1763#
FRONT PORCH	113#
SIDE PORCH	168#
TOTAL AREA	2044#

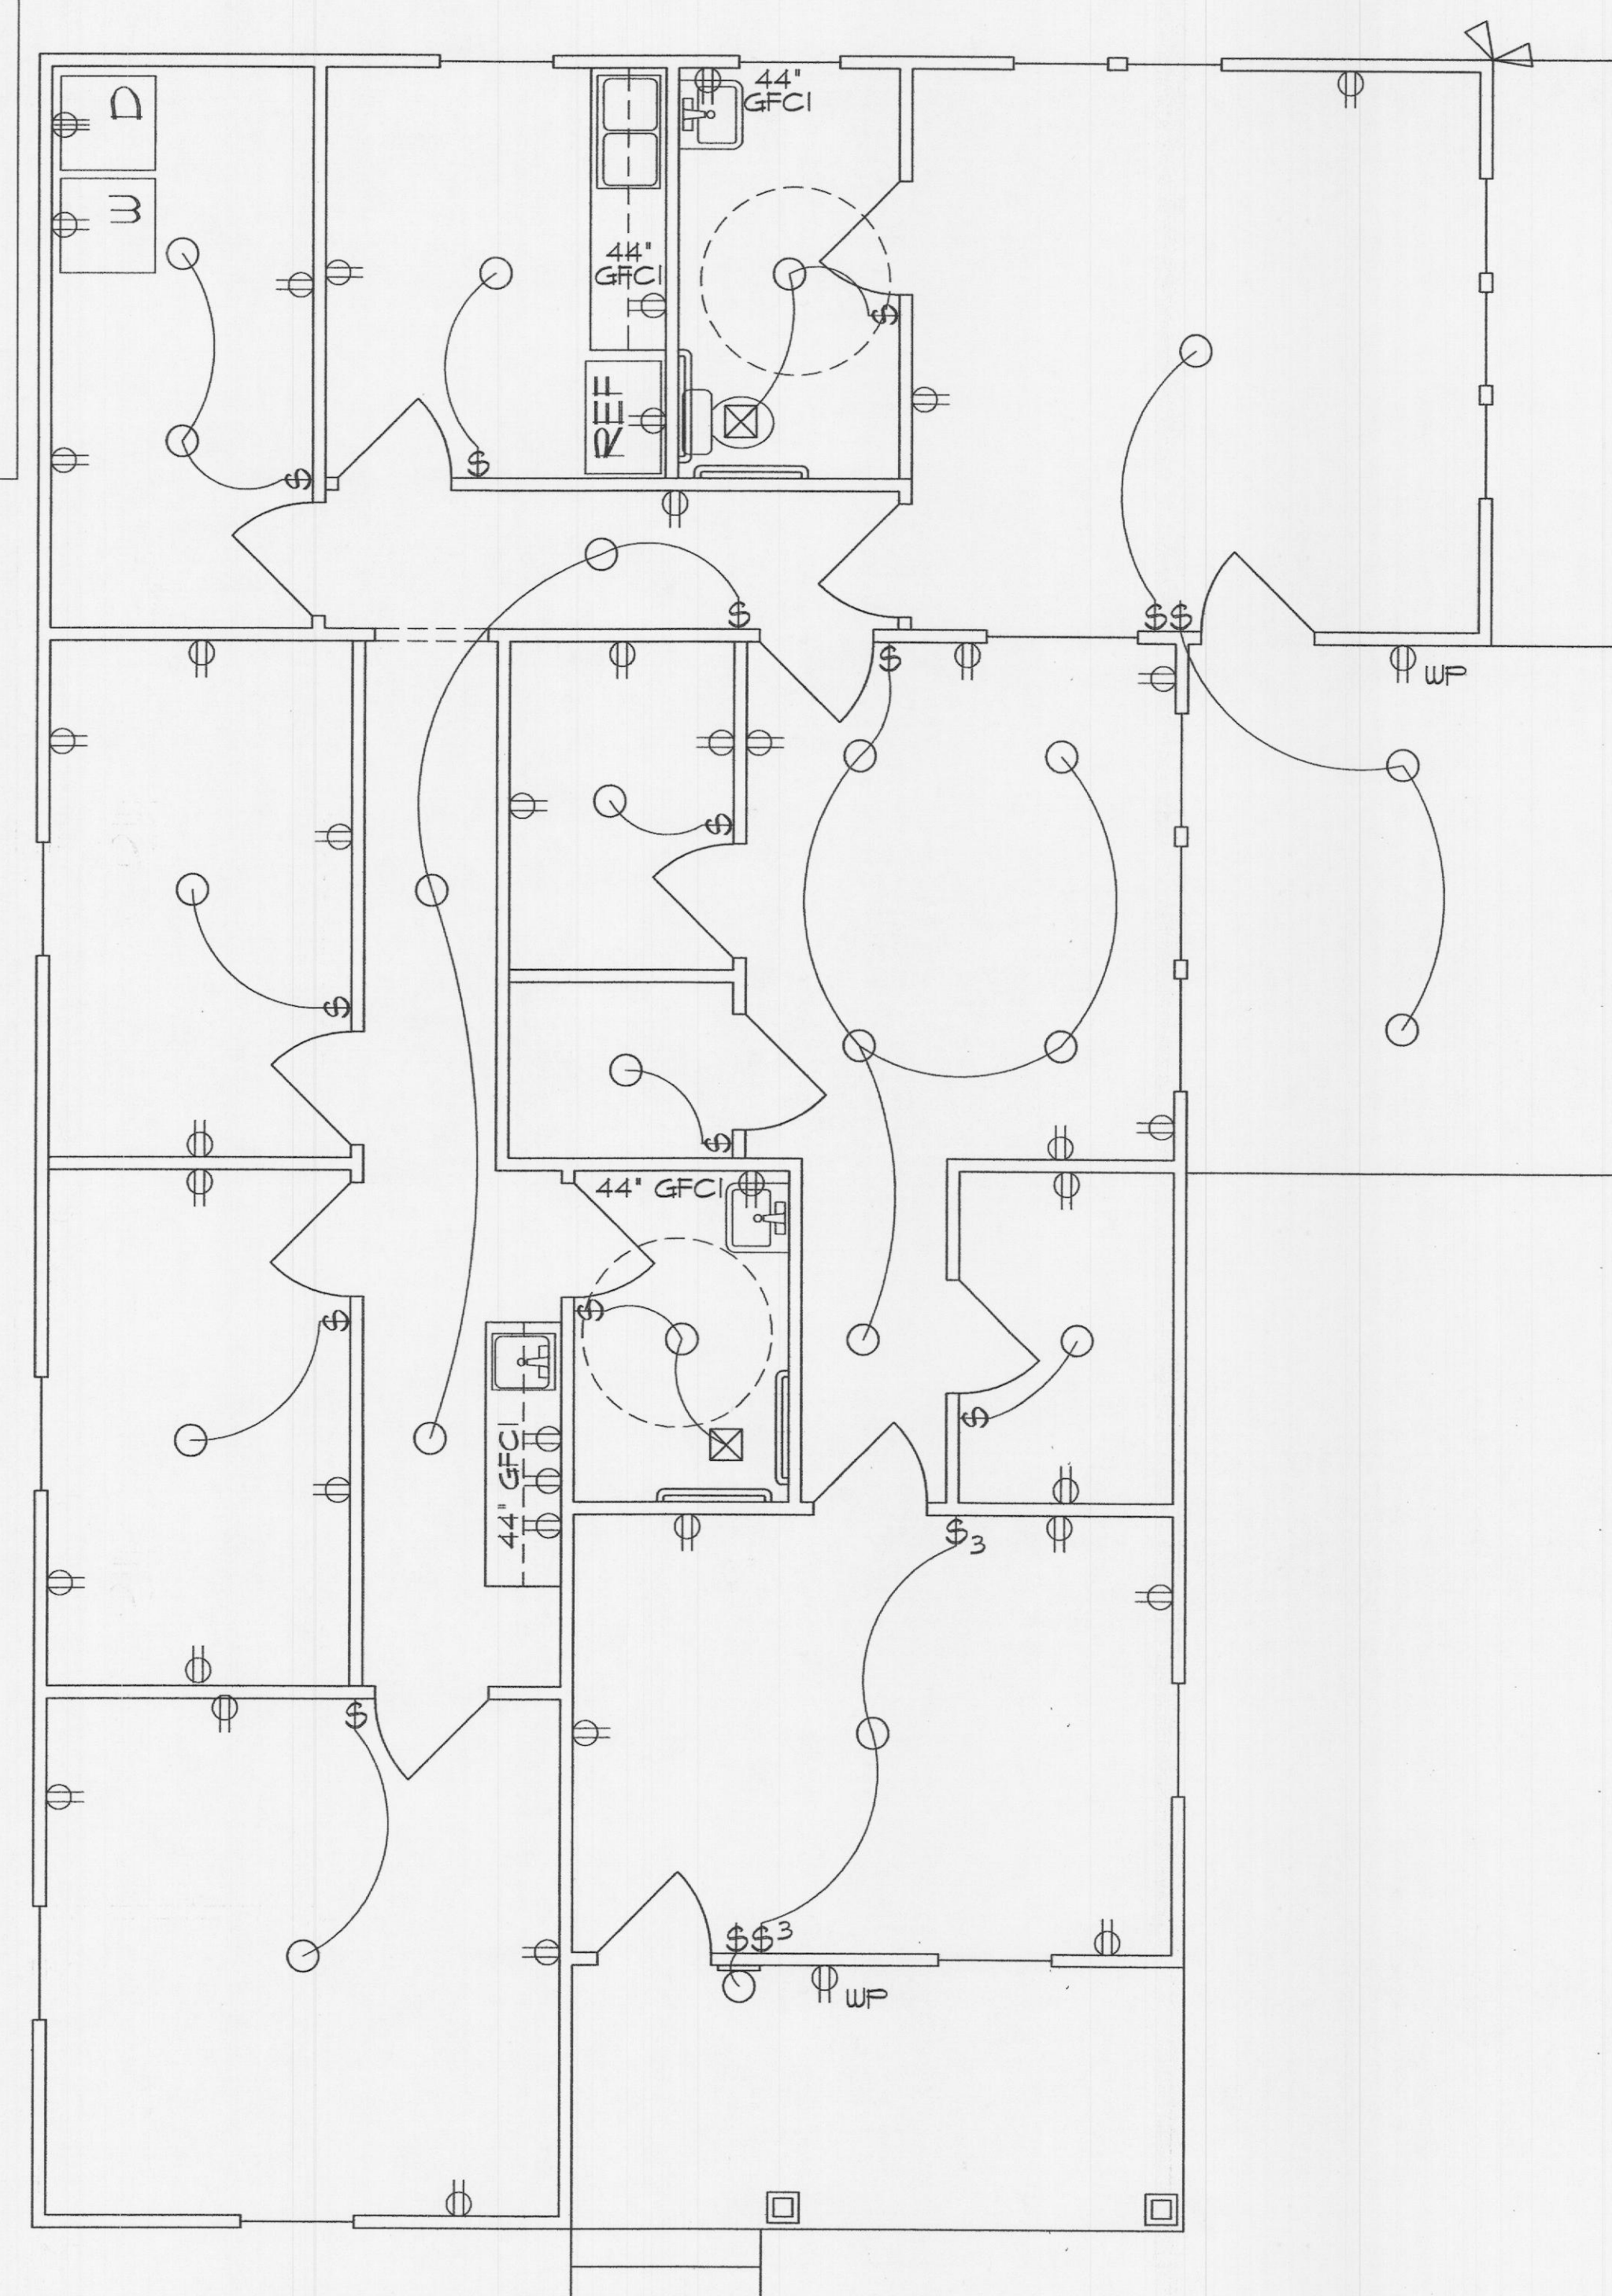

TITLE:
FLOOR PLAN / ELECTRICAL PLAN

SCALE:
AS SHOWN

SHANNON NEWSON
MARK NEWSON
CADAZIGN
3109 C.R. 2522
ROYSE CITY, TEXAS 75189
469-338-9863

DATE
11/08/16

REVISION DATE:

SHEET A2

JOB NO.
18516CAD

ROCKWALL
FREE CLINIC
602 NORTH GOLIAD
ROCKWALL, TEXAS 75087




① FRONT ELEVATION
SCALE: 1/4"=1'-0"




② REAR ELEVATION
SCALE: 1/4"=1'-0"



③ RIGHT ELEVATION
SCALE: 1/4"=1'-0"

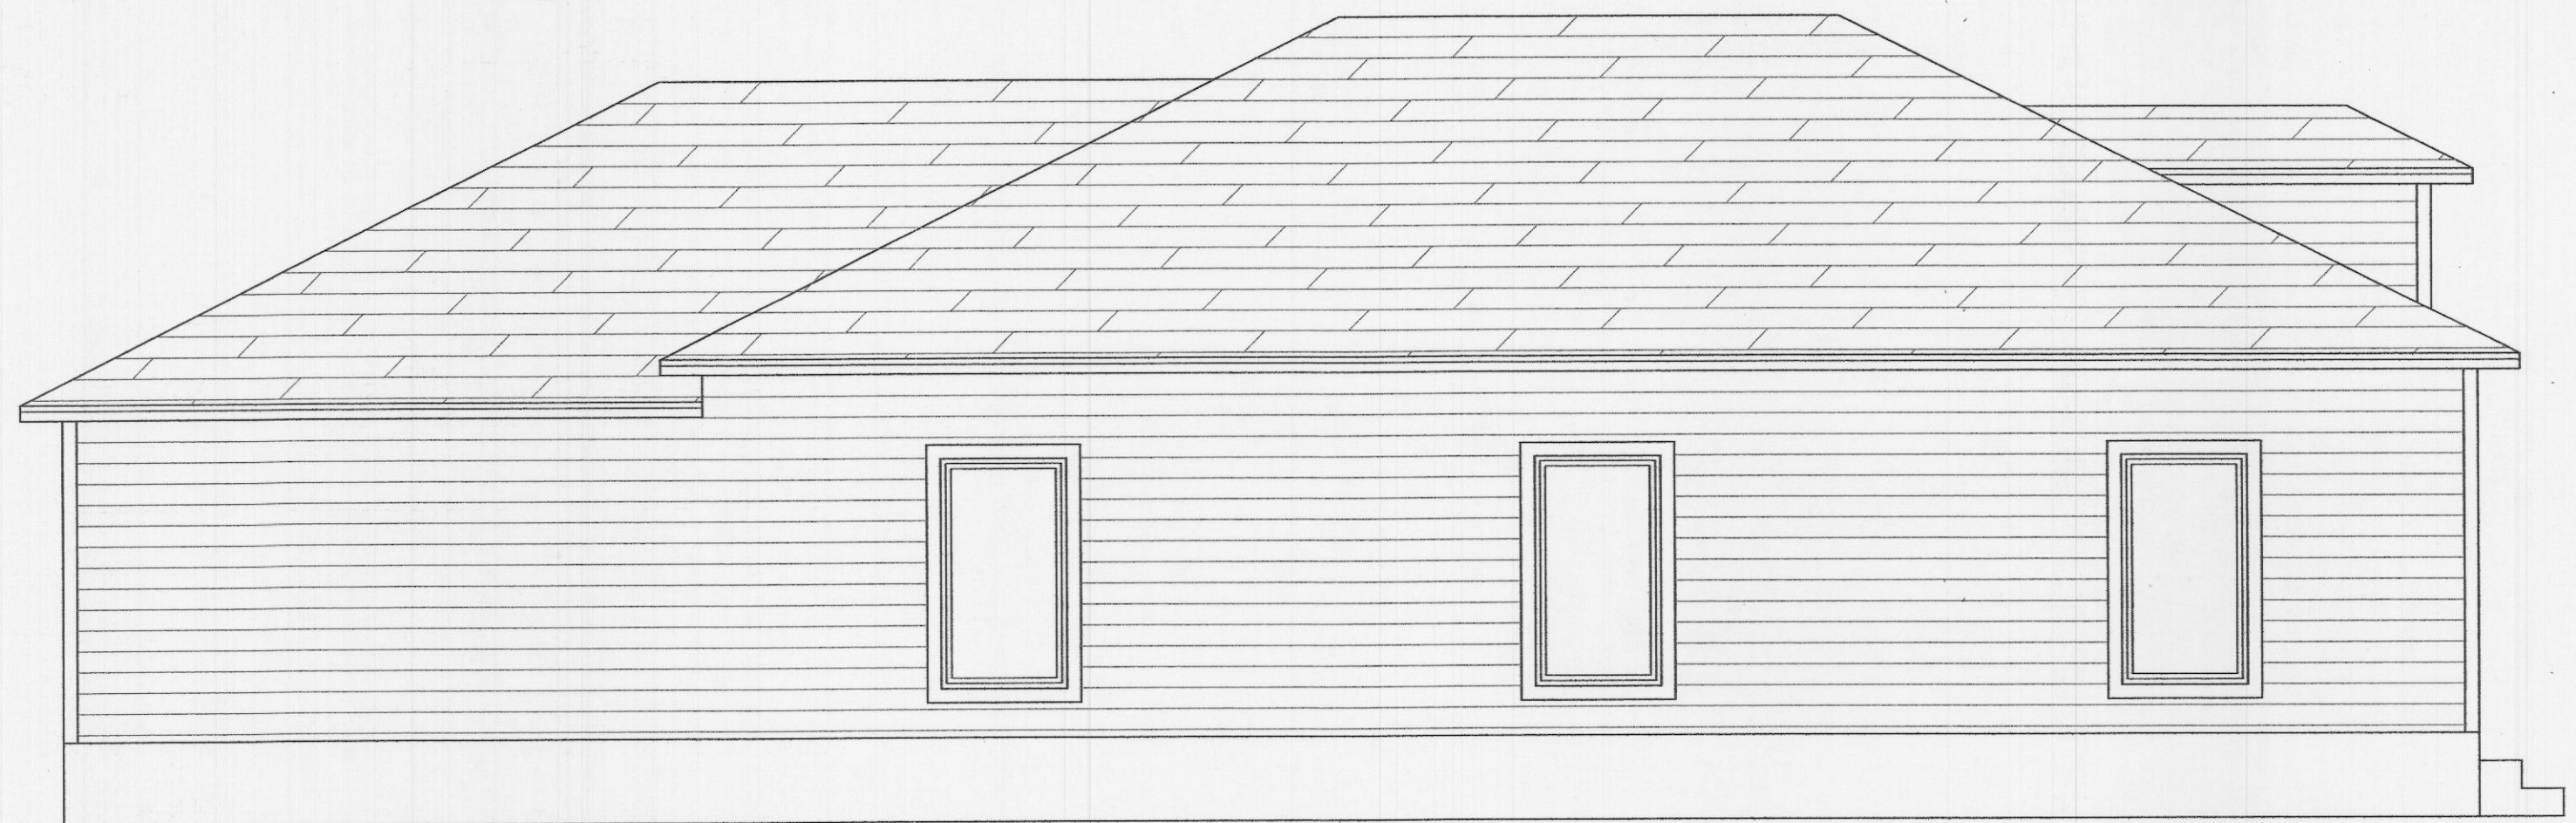

④ LEFT ELEVATION
SCALE: 1/4"=1'-0"

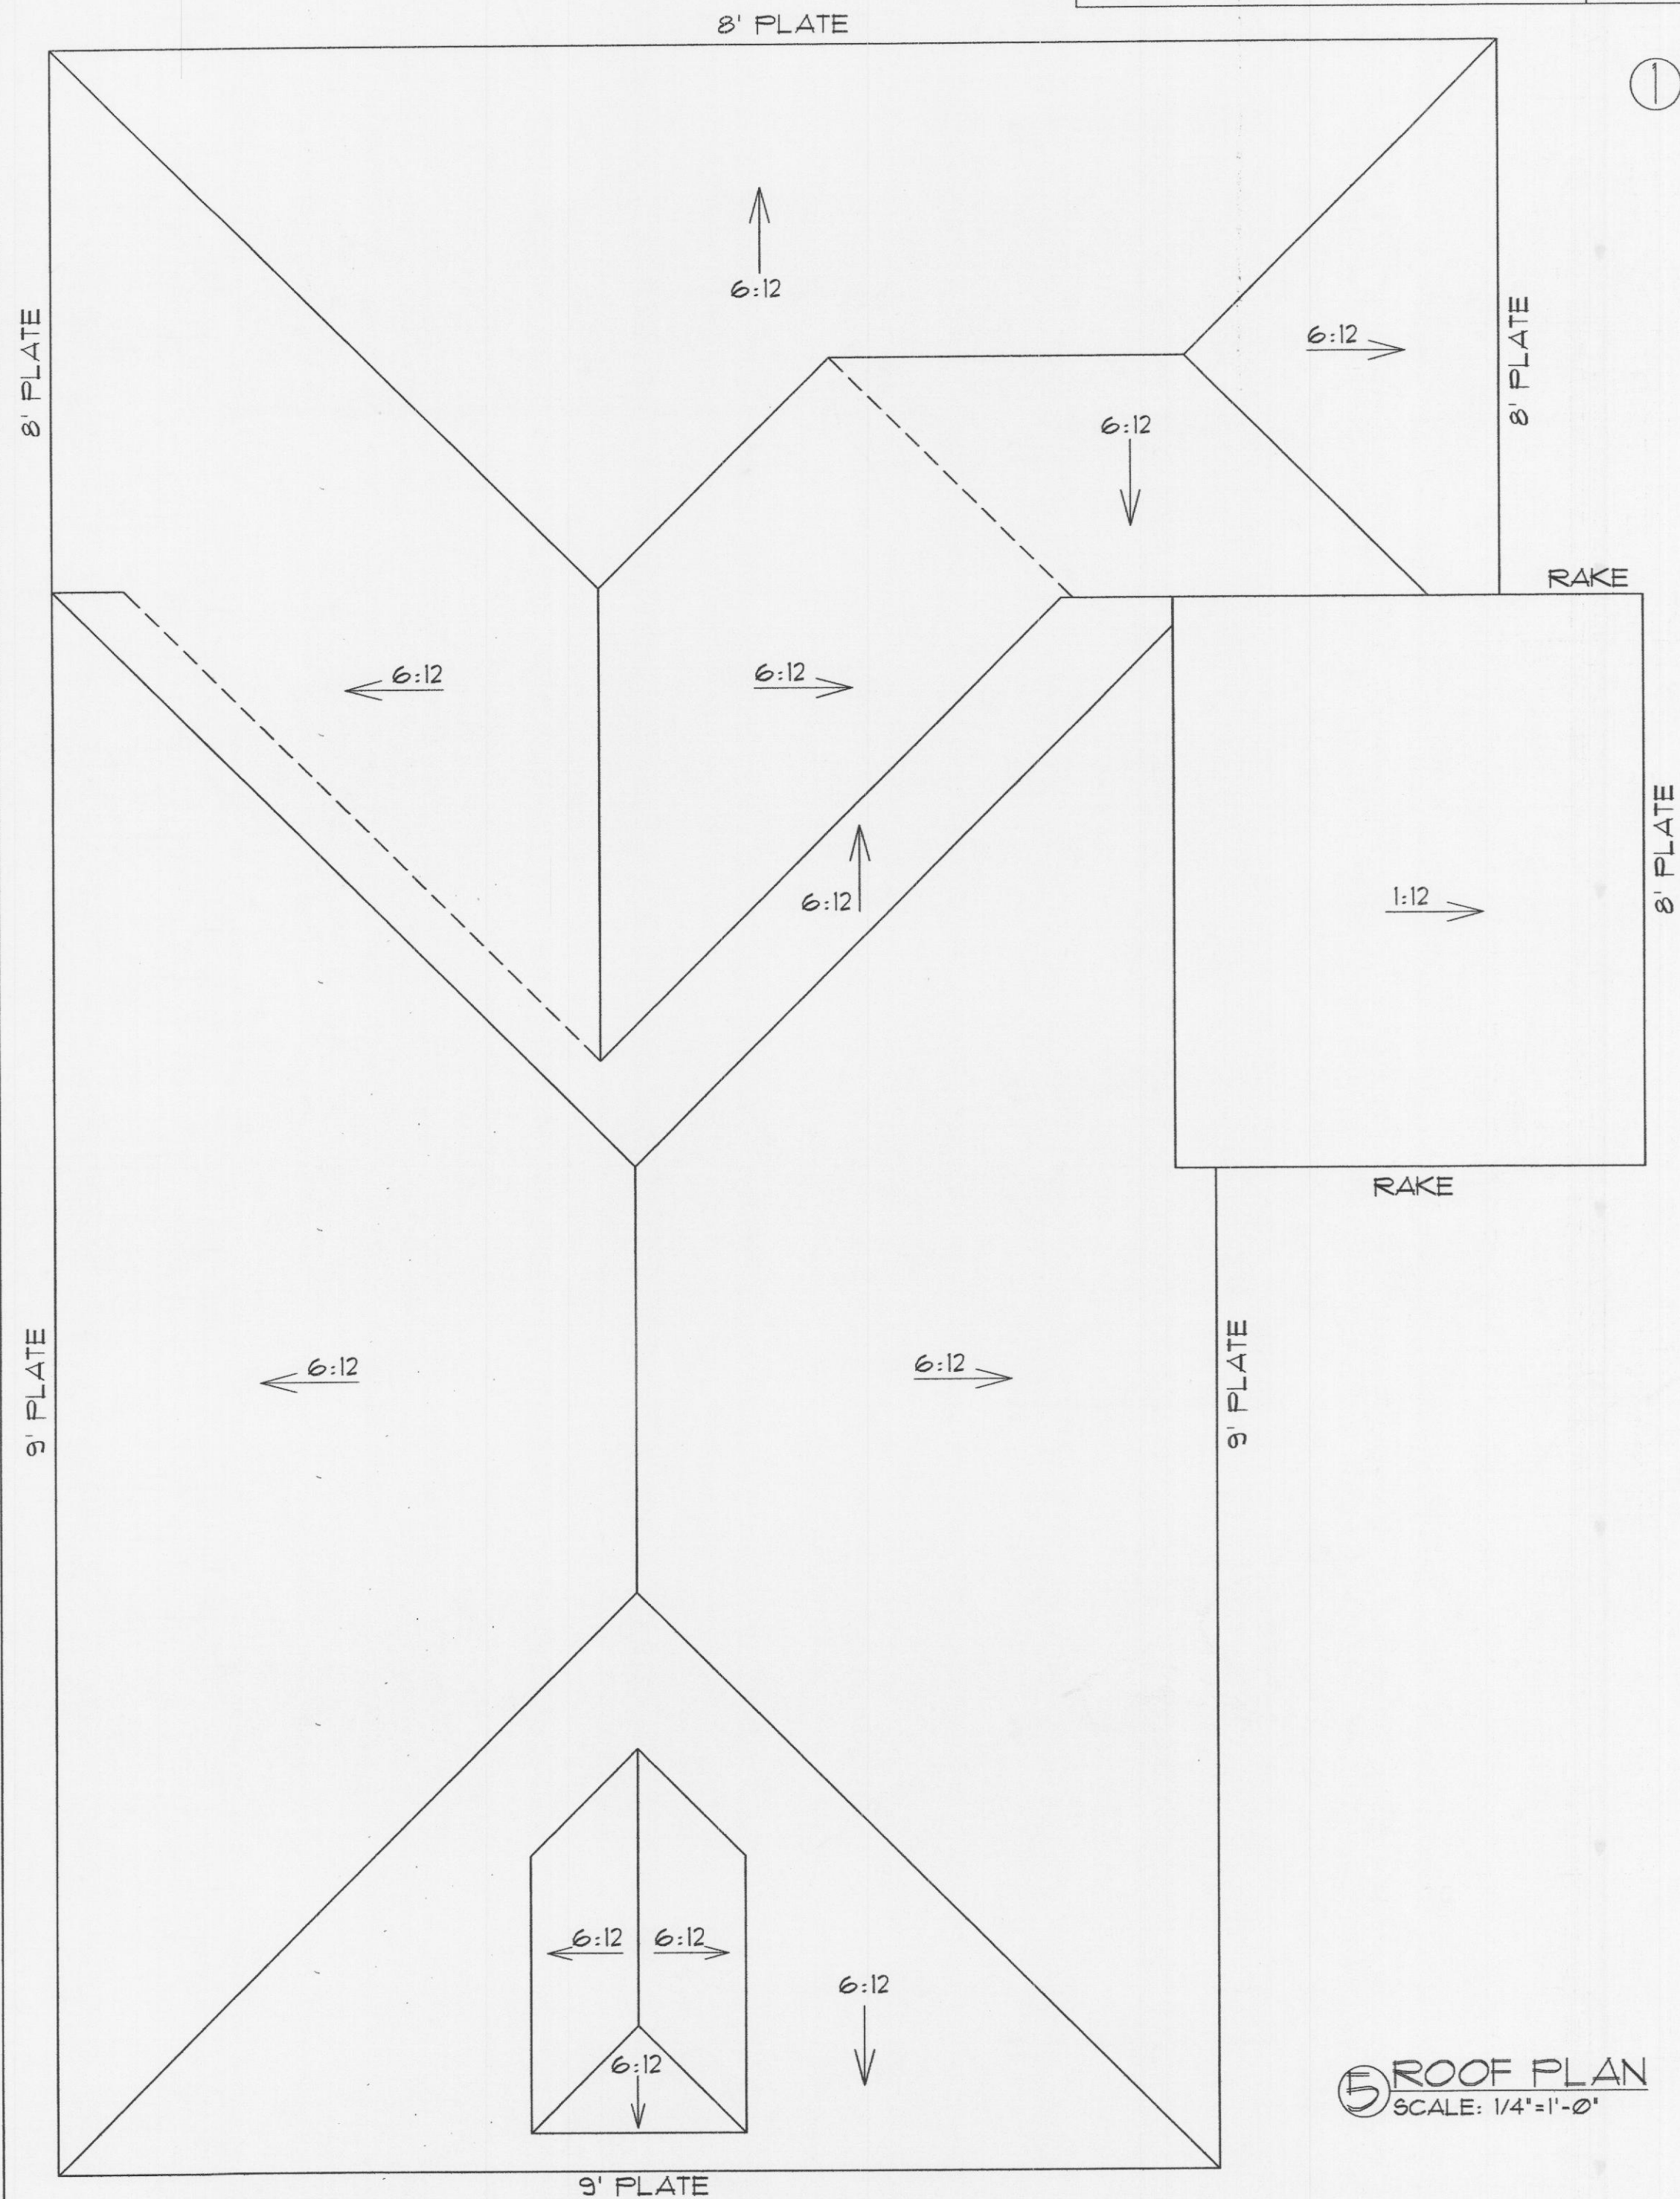

⑤ ROOF PLAN
SCALE: 1/4"=1'-0"

ROCKWALL
FREE CLINIC
602 NORTH GOLIAD
ROCKWALL, TEXAS 75087

TITLE:
ELEVATIONS & ROOF PLAN

SCALE:
AS SHOWN

SHANNON NEWBOM
MARK NEWBOM
CADAZIGN
3709 C.R. 2522
ROYSE CITY, TEXAS 75189
469-338-9863

DATE
11/08/16

REVISION DATE:

SHEET
A1

JOB NO.
18516CAD